

# 3122 M Street NW - Location Map

Not to Scale

3122 M Street NW Washington, D. C. 20007 - Apartment Renovation/Addition  
21 January 2022






M Street NW - Context Photo

Not to Scale

3122 M Street NW Washington, D. C. 20007 - Apartment Renovation/Addition  
21 January 2022



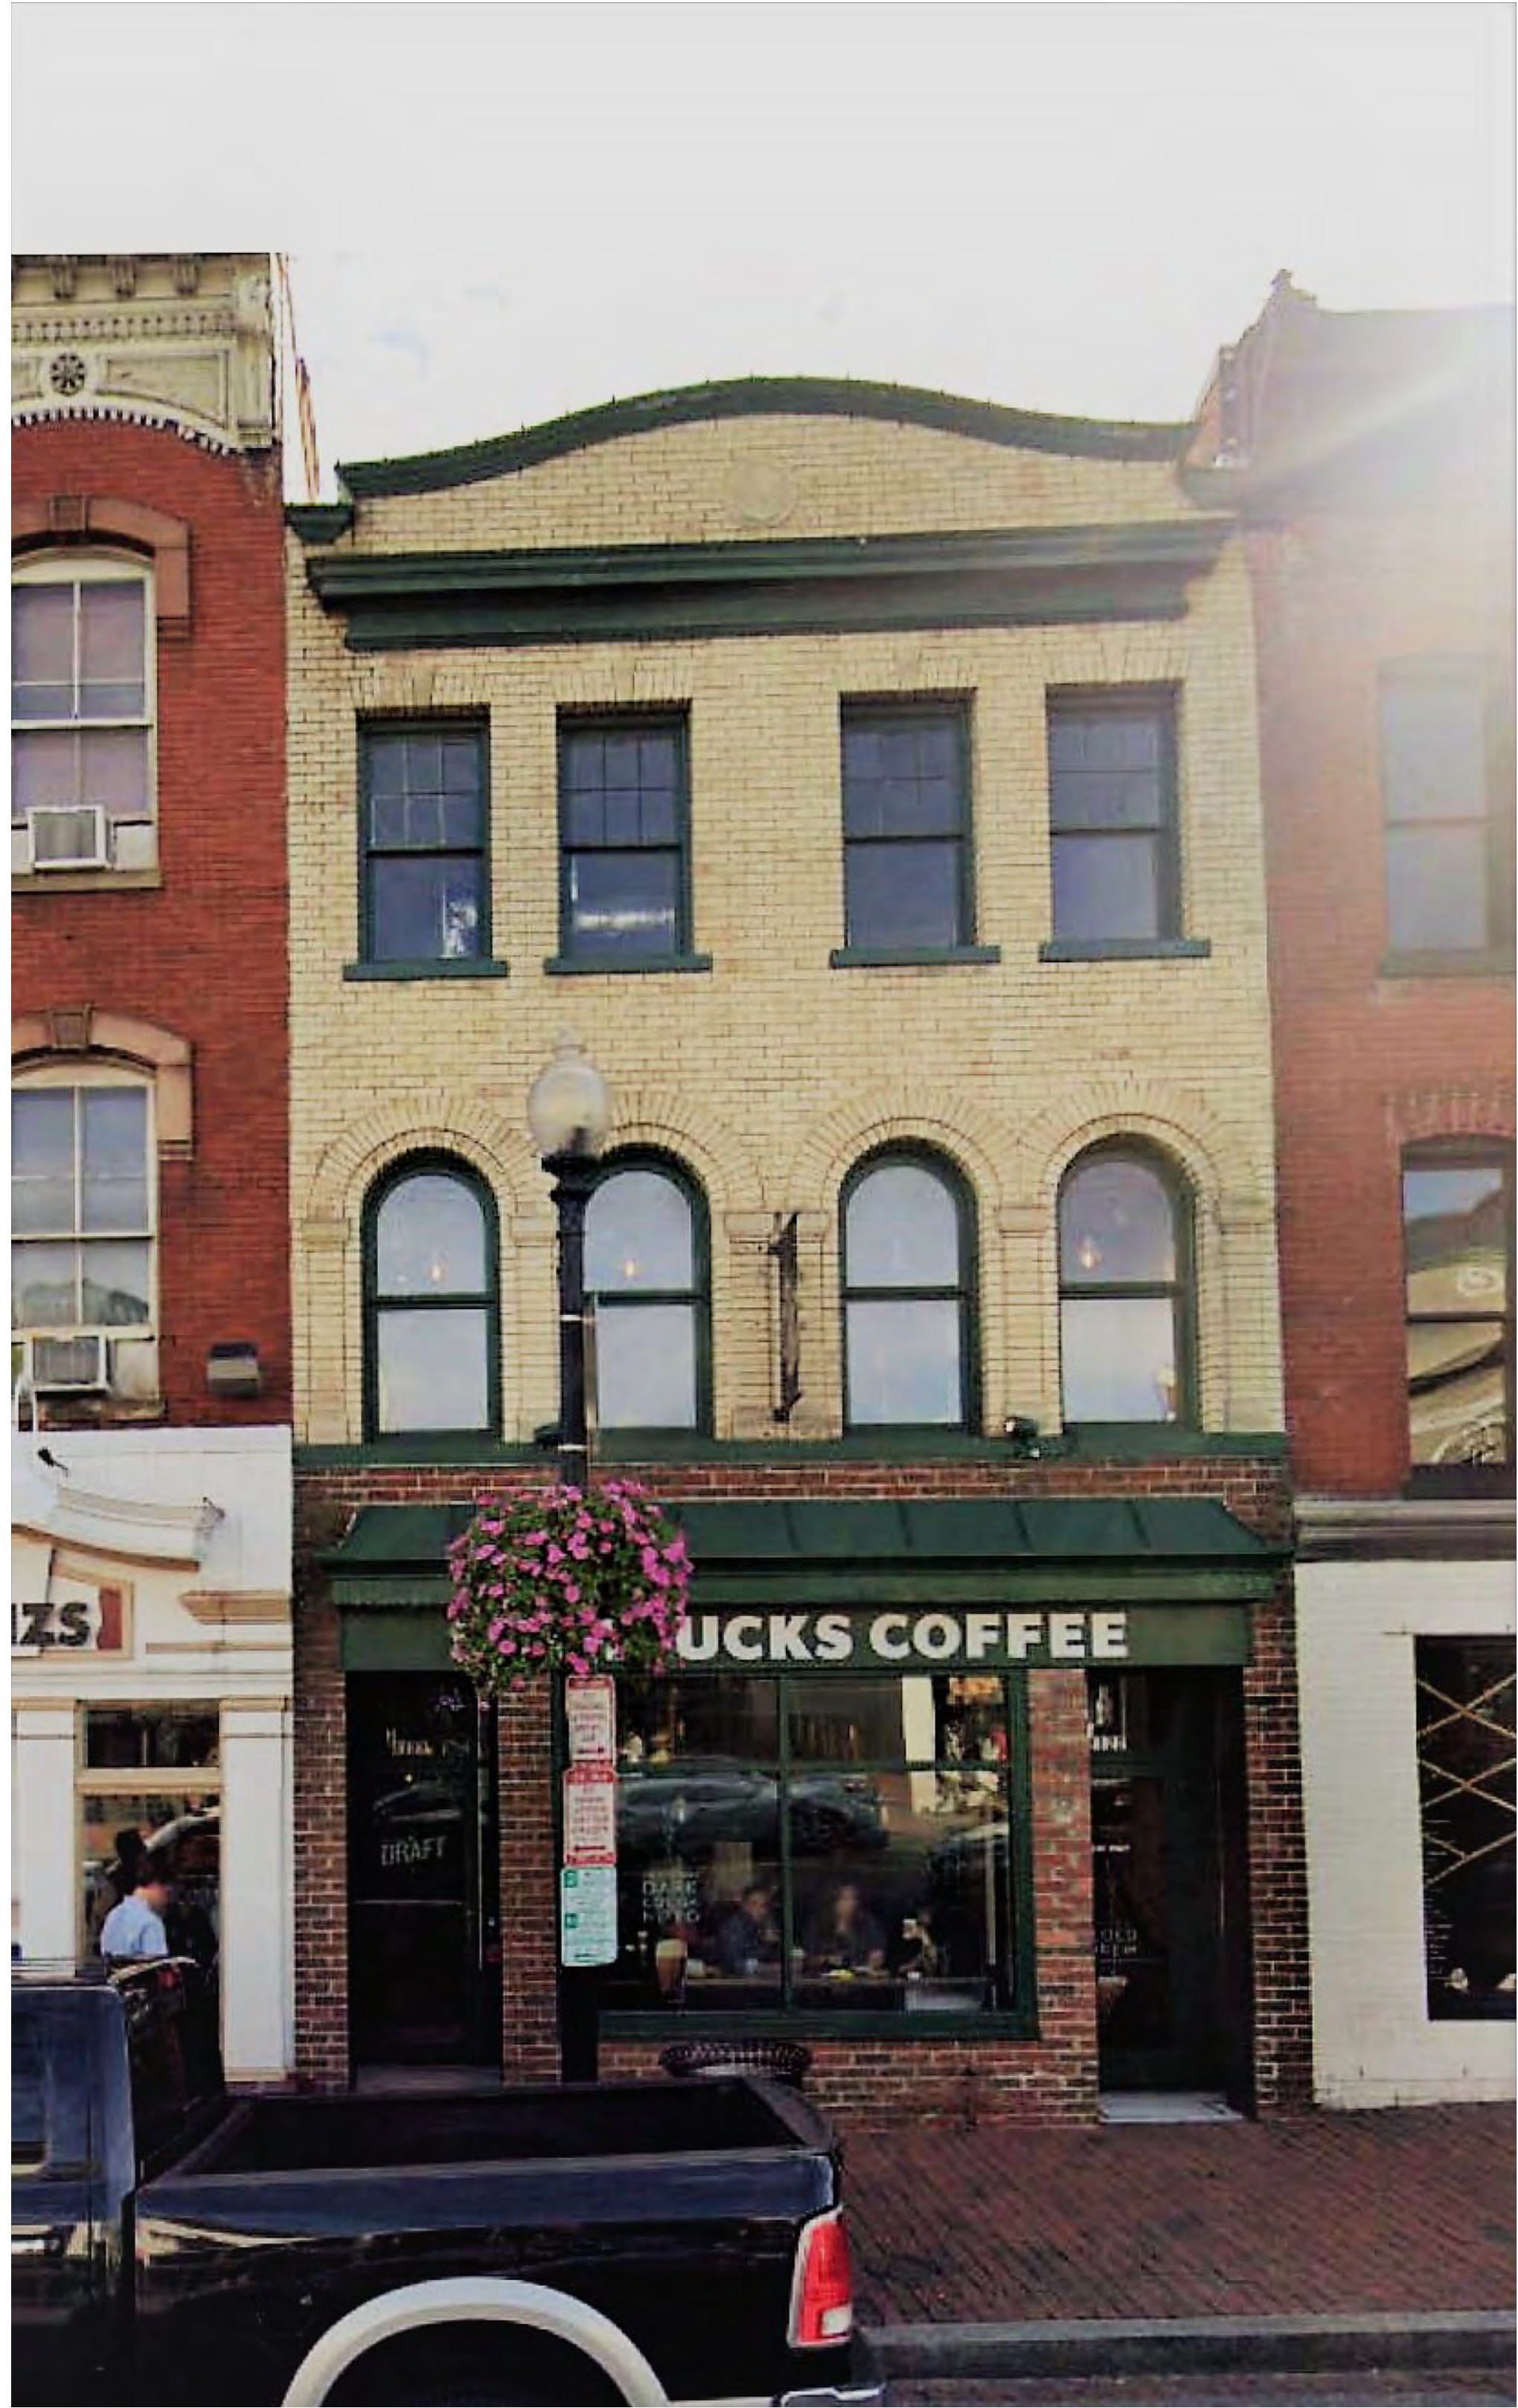


# 3122 M Street NW - Storefront Photos

Not to Scale


3122 M Street NW Washington, D. C. 20007 - Apartment Renovation/Addition  
21 January 2022



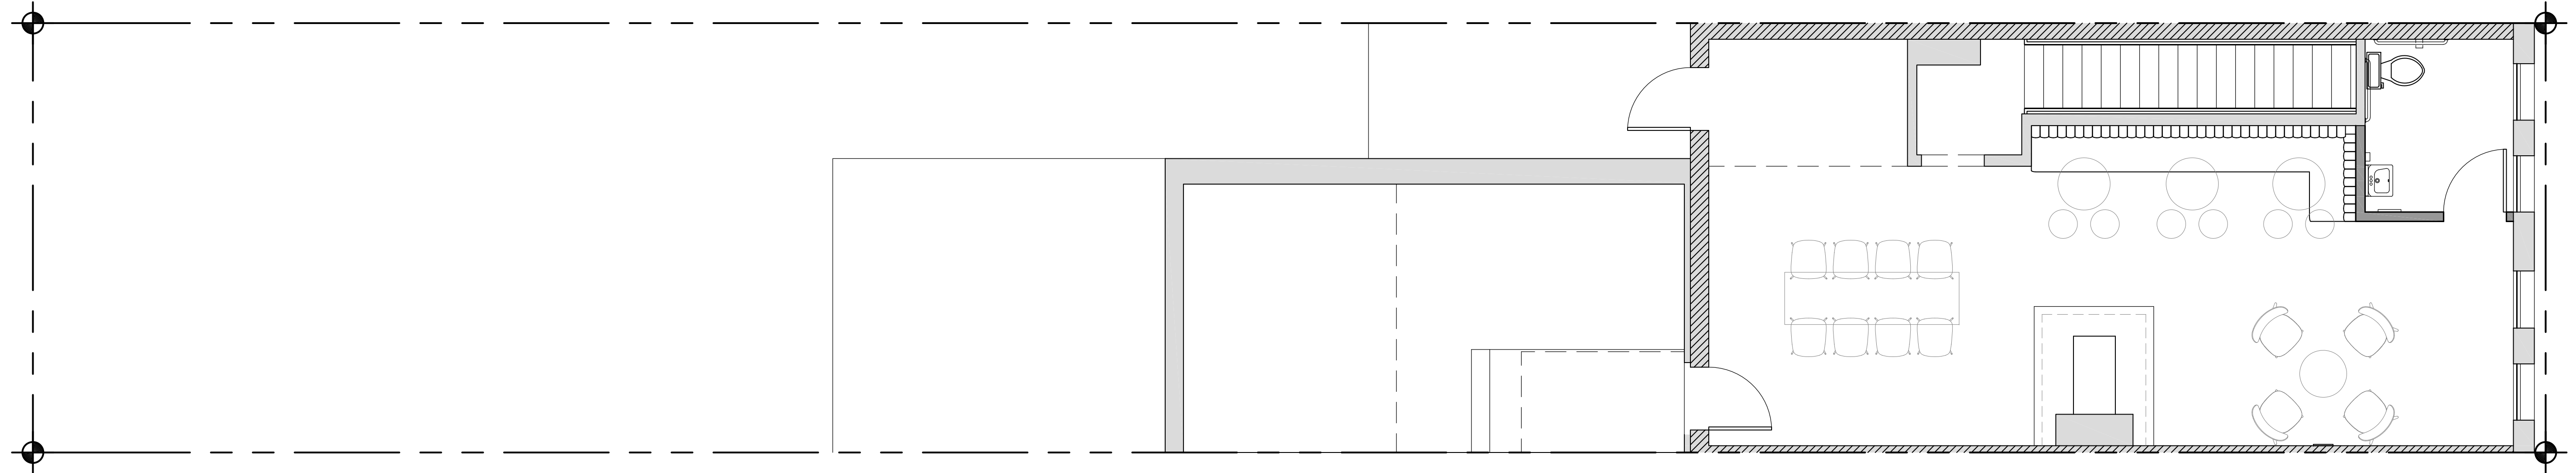

Second Floor Plan - Interior

Scale:  $\frac{1}{4}" = 1' = 0"$

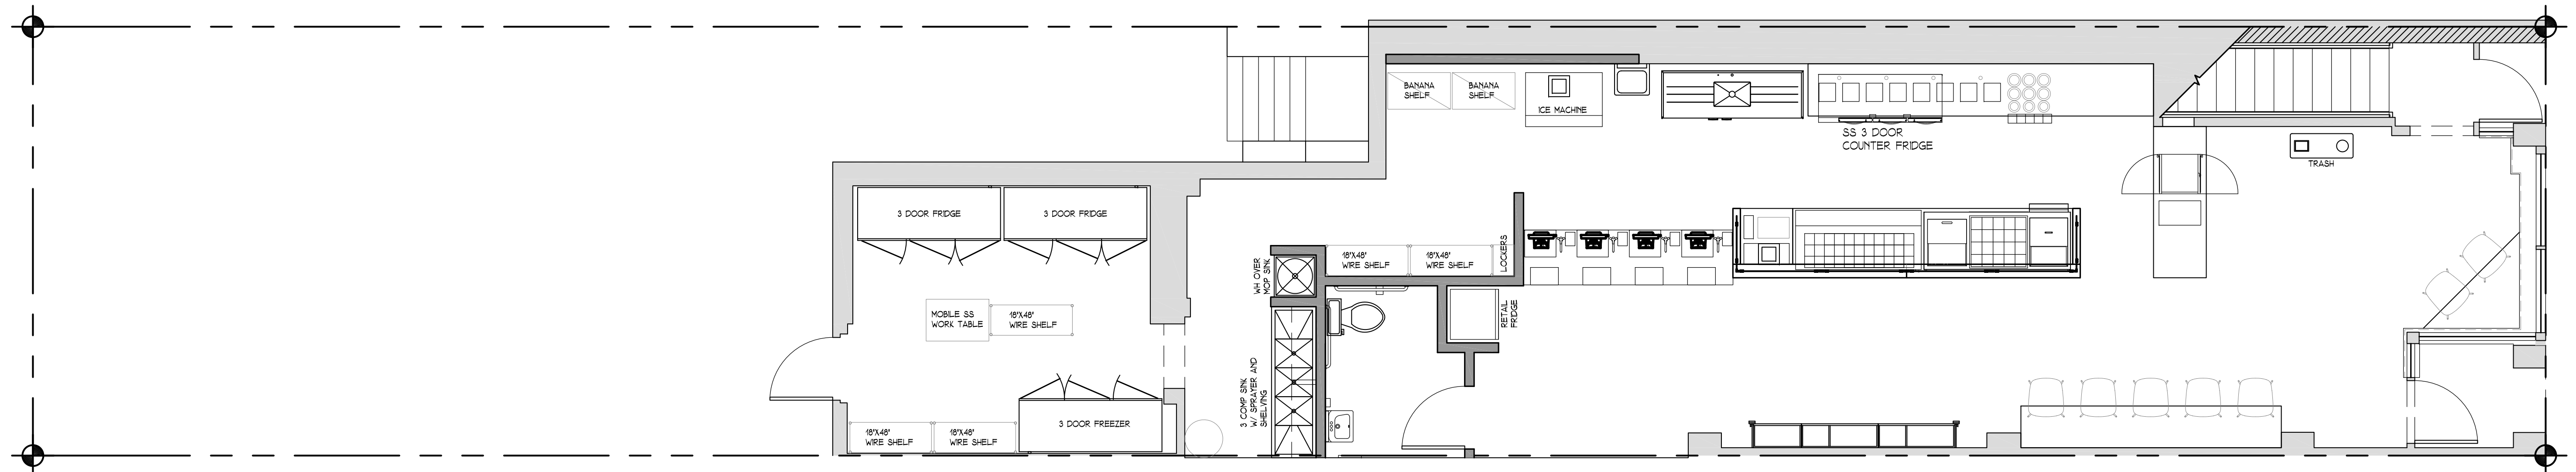


First Floor Plan - Interior

Scale:  $\frac{1}{4}" = 1' = 0"$

## Interior Construction Plans

Scale:  $\frac{1}{4}" = 1' = 0"$



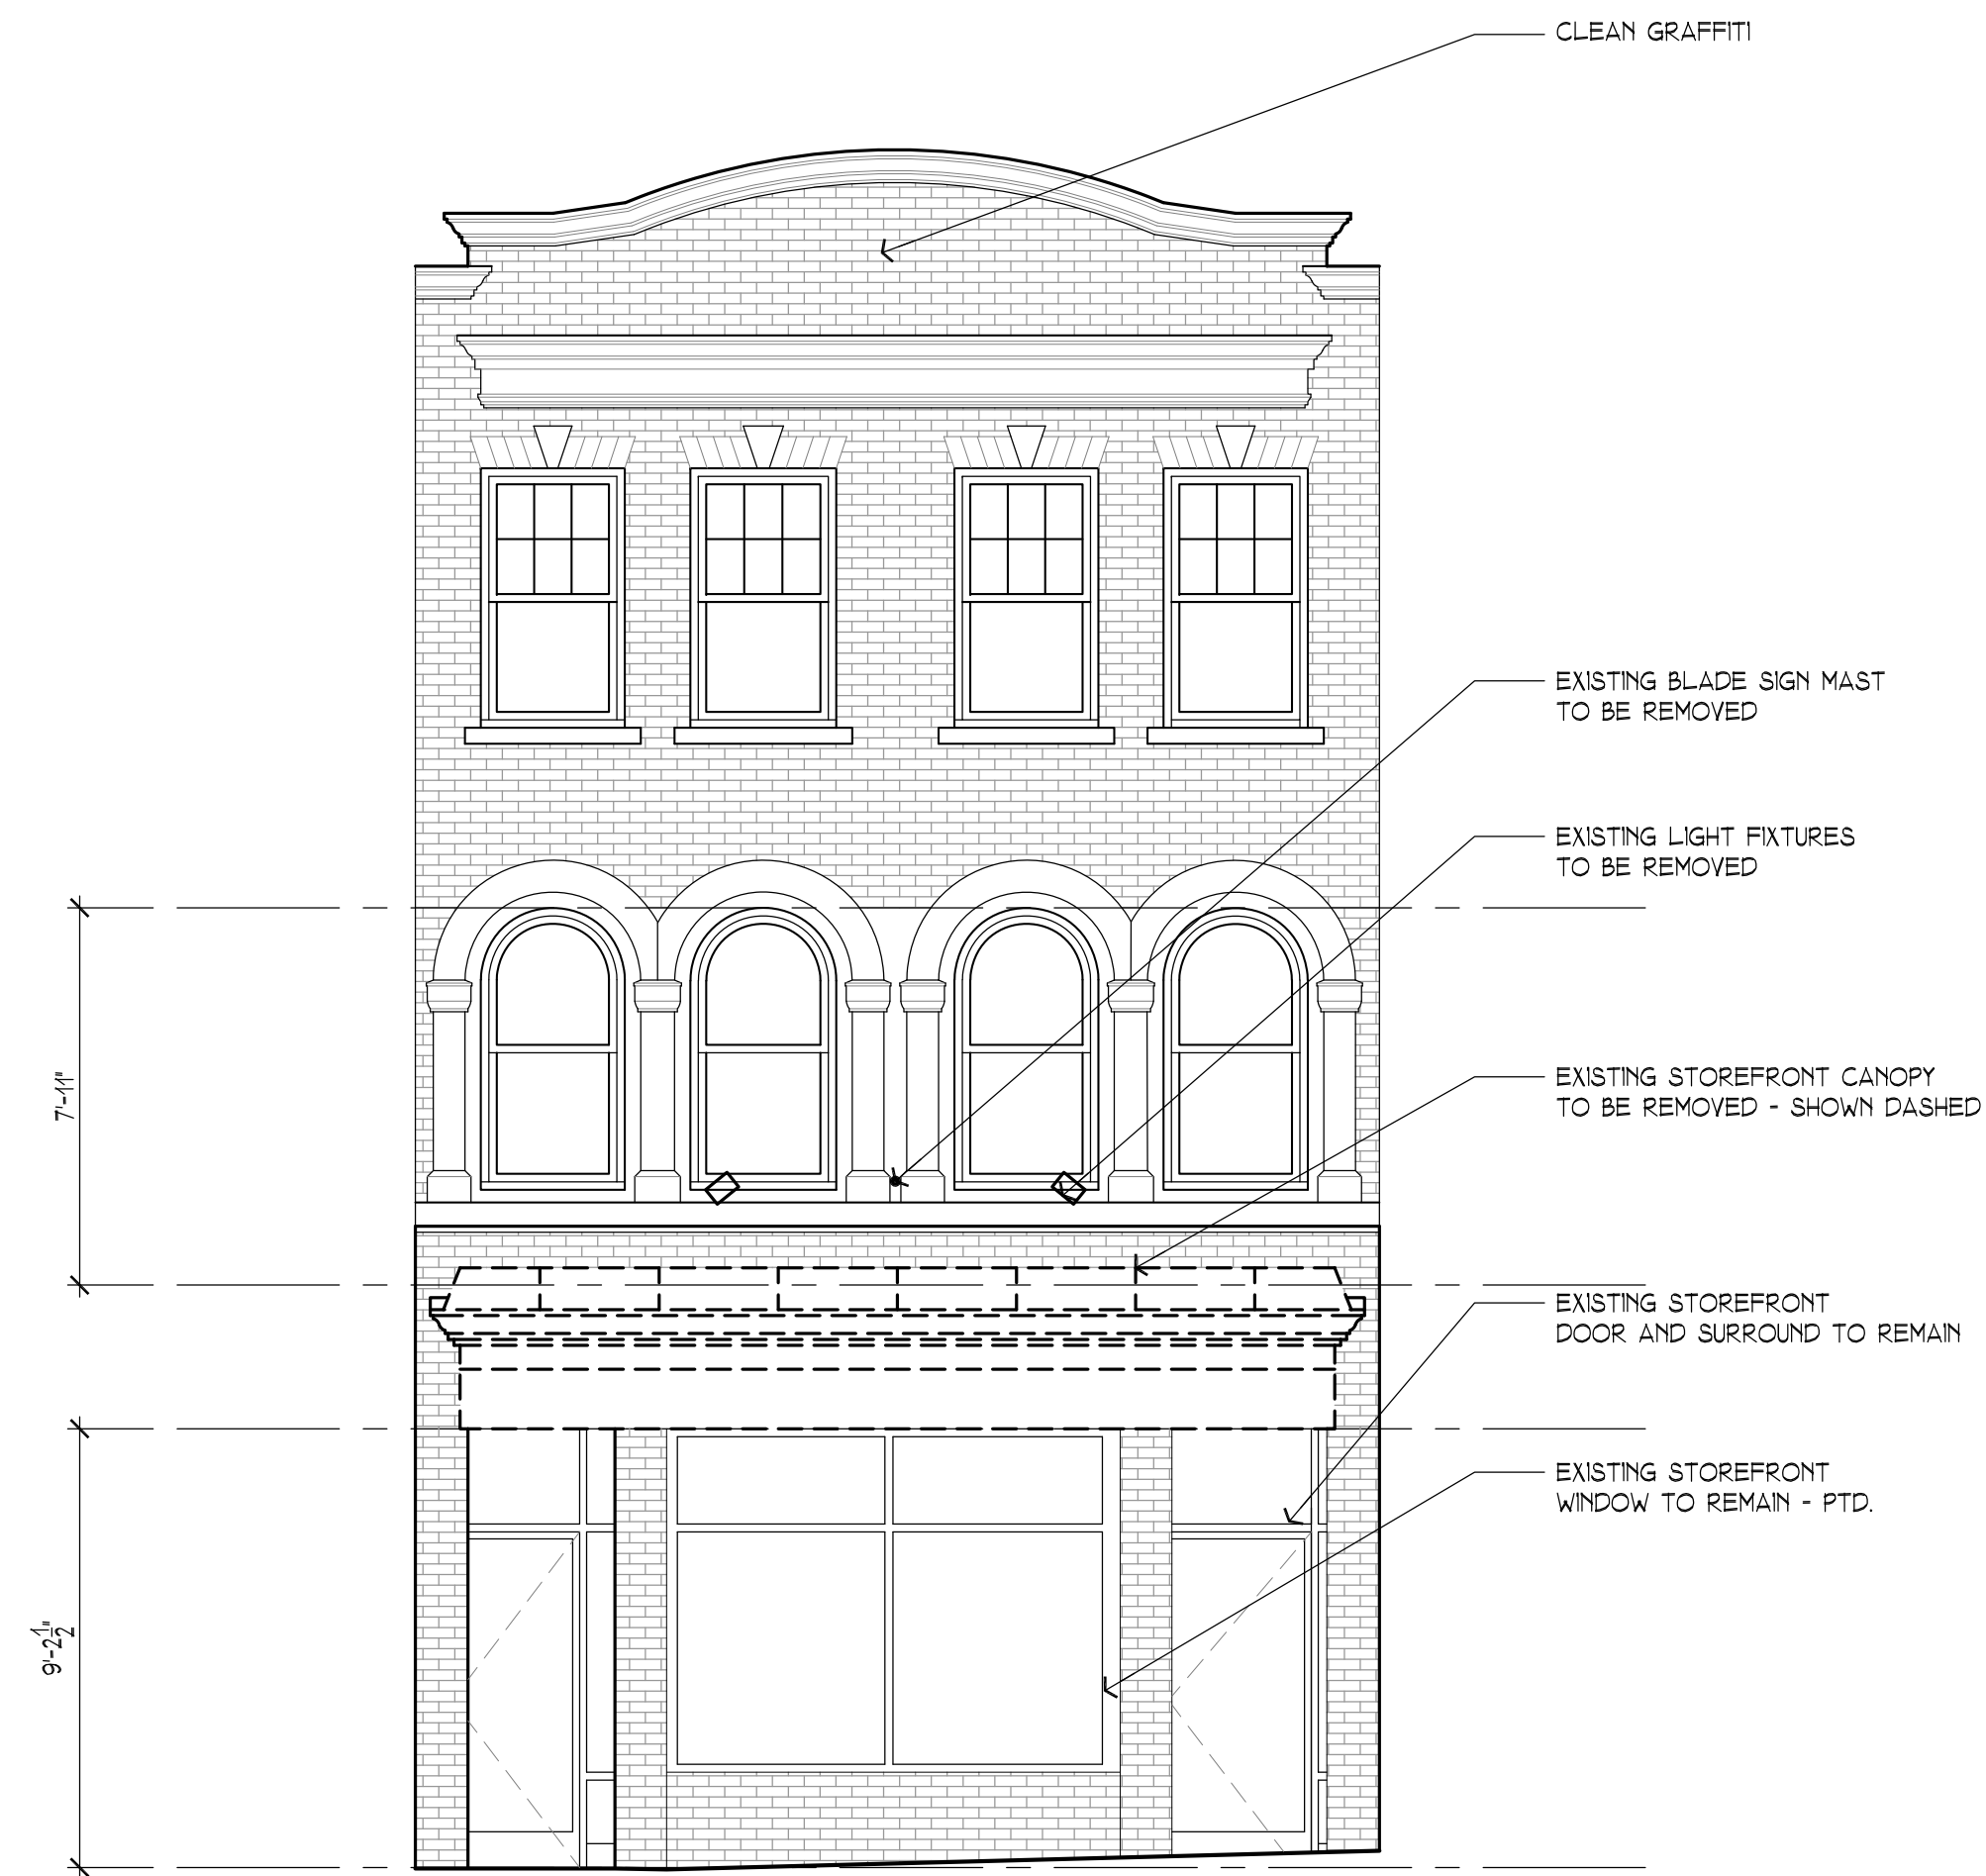





## Existing/Demo. Storefront Elevation

Scale:  $\frac{1}{4}" = 1'-0"$

3122 M Street NW Washington, D. C. 20007 - Apartment Renovation/Addition  
21 January 2022

A003



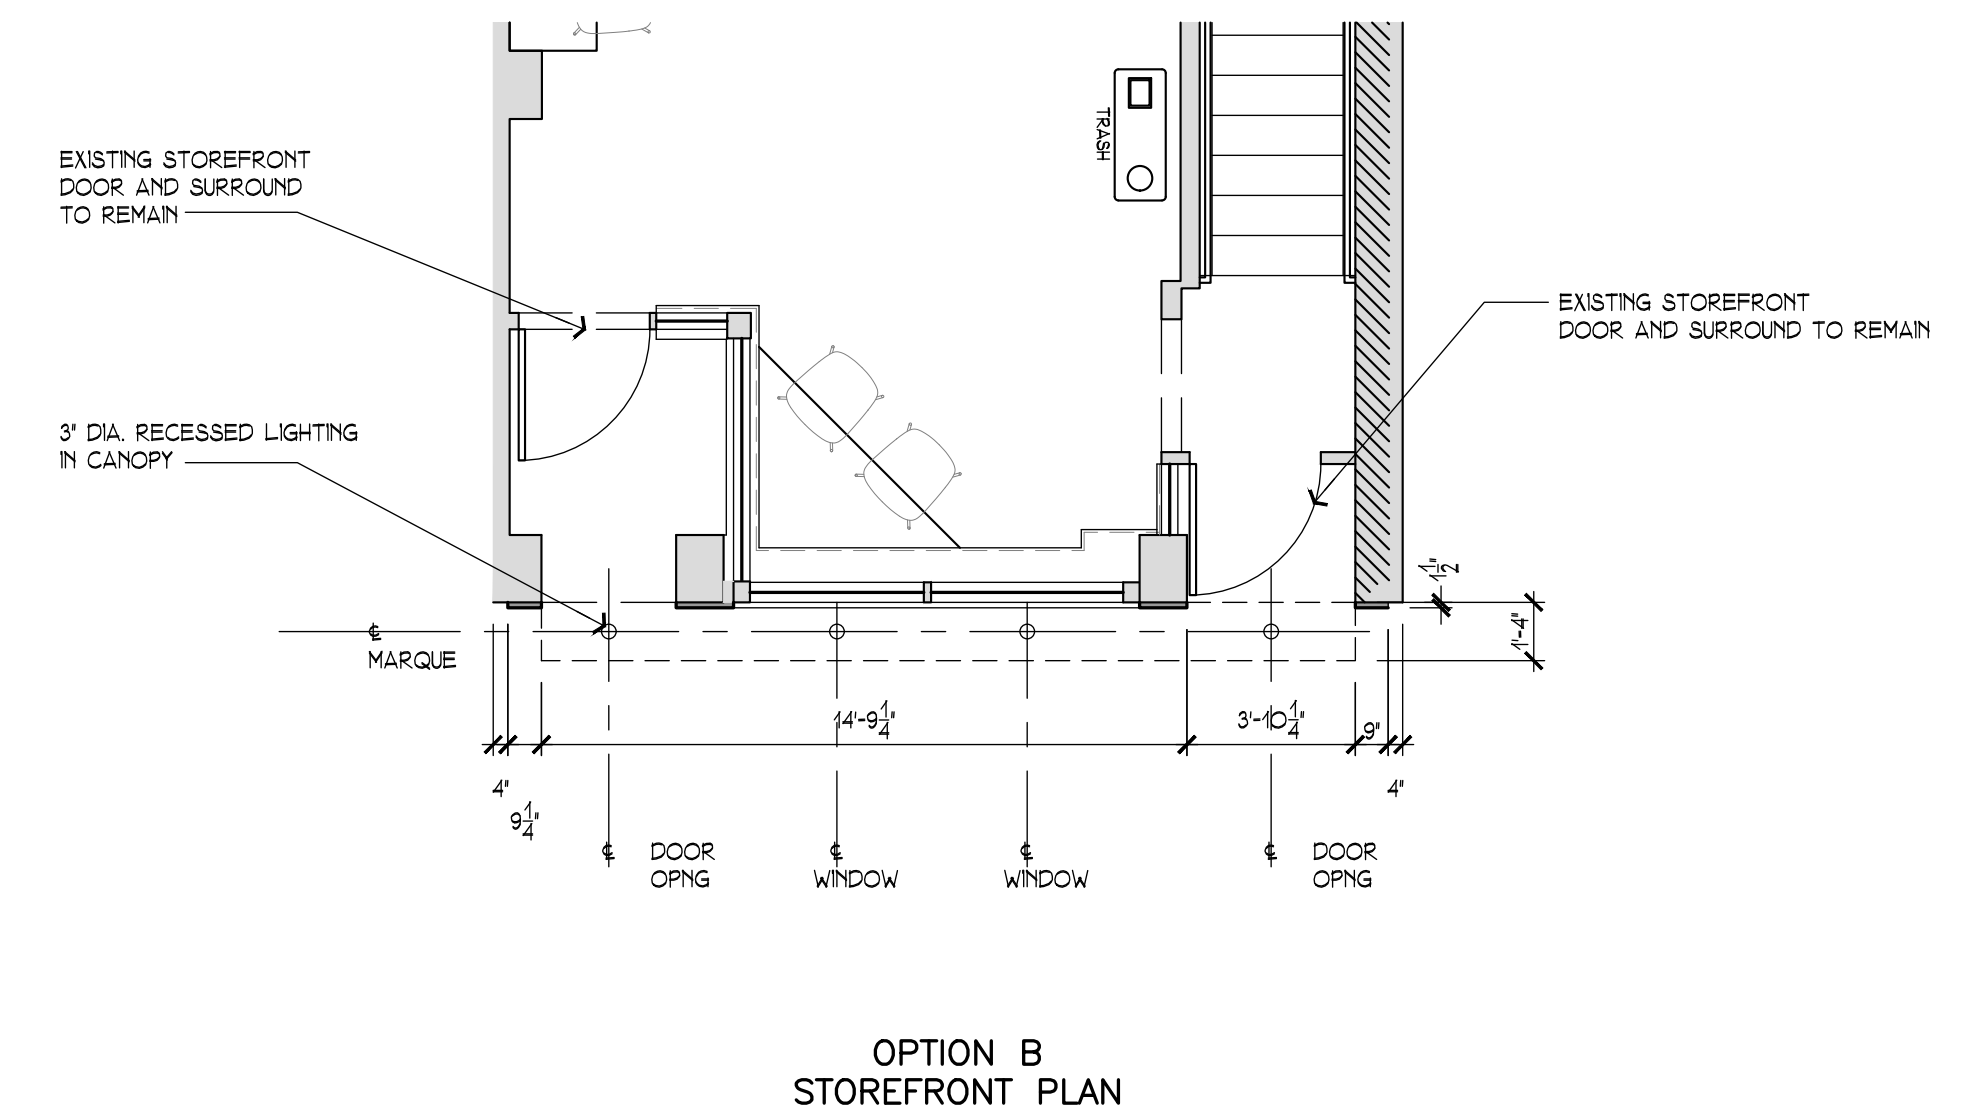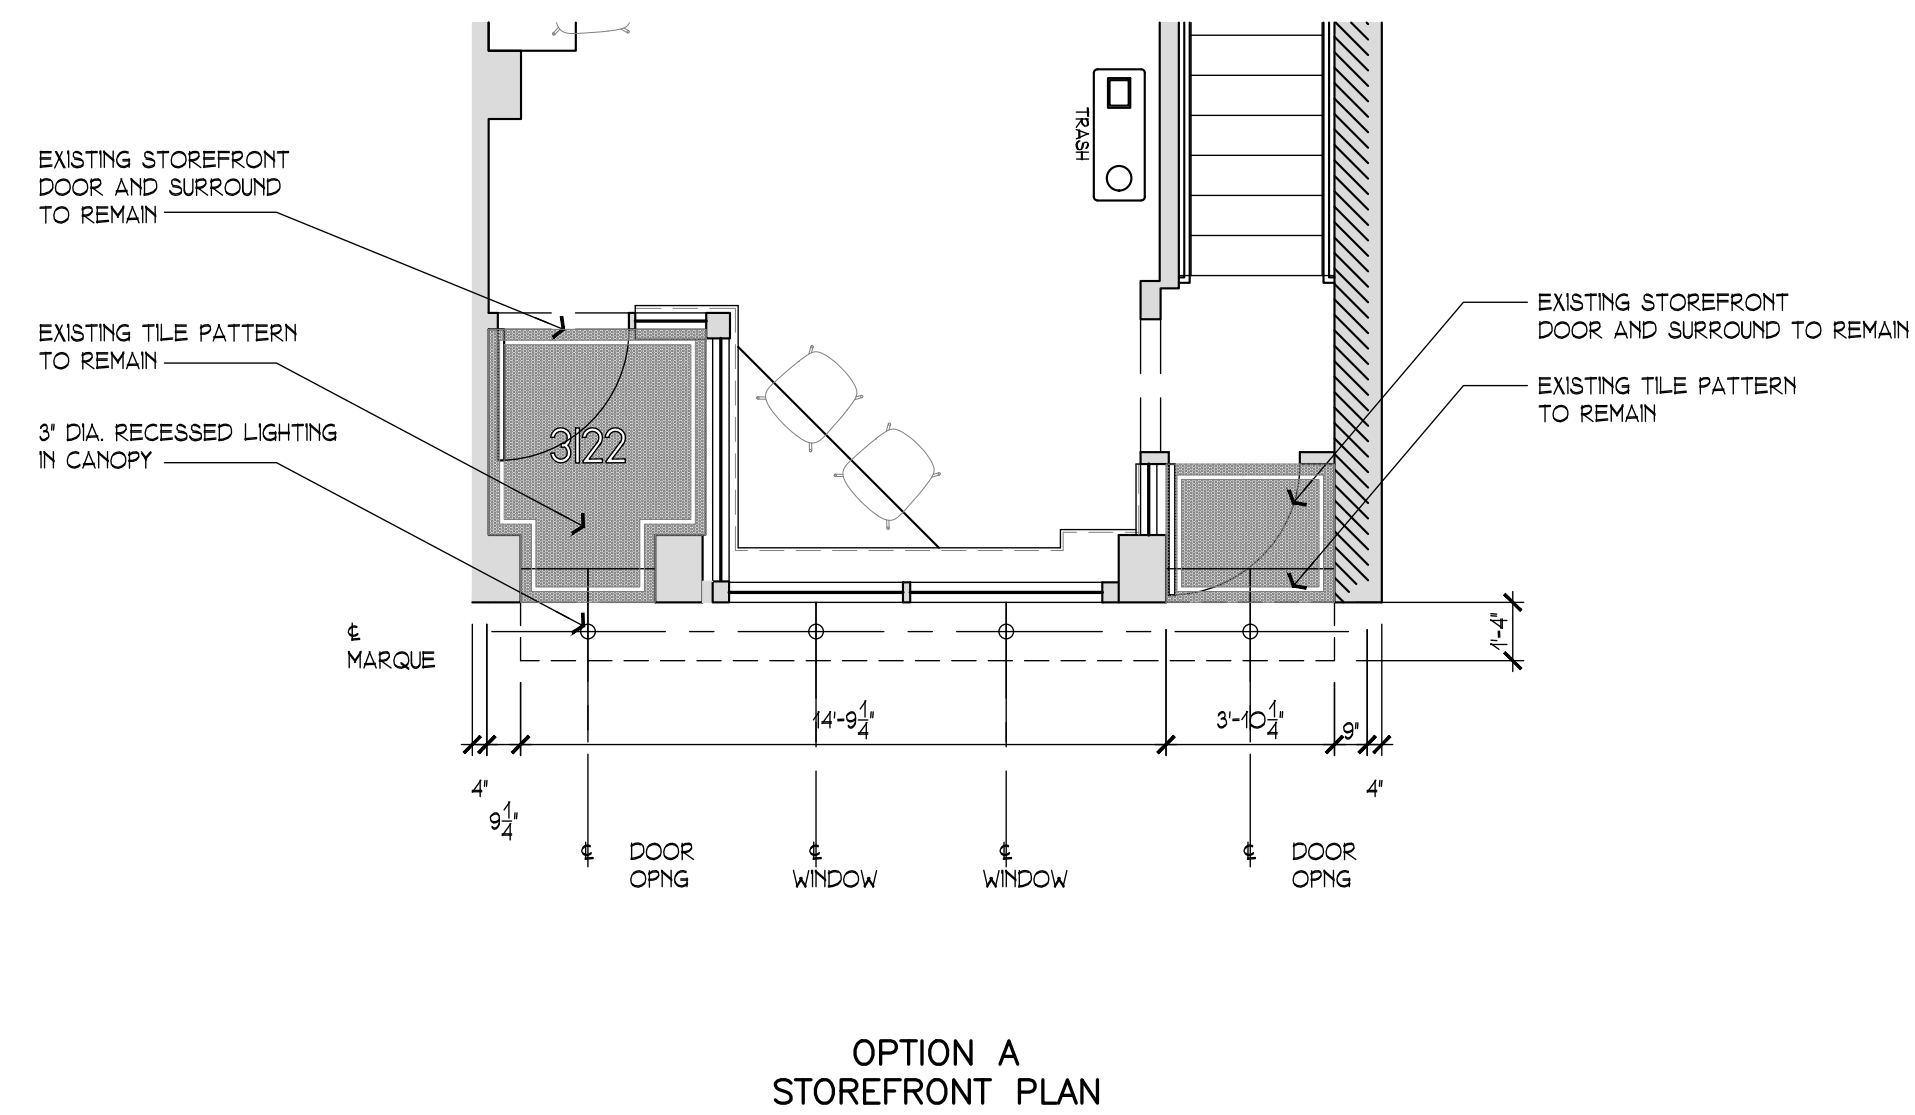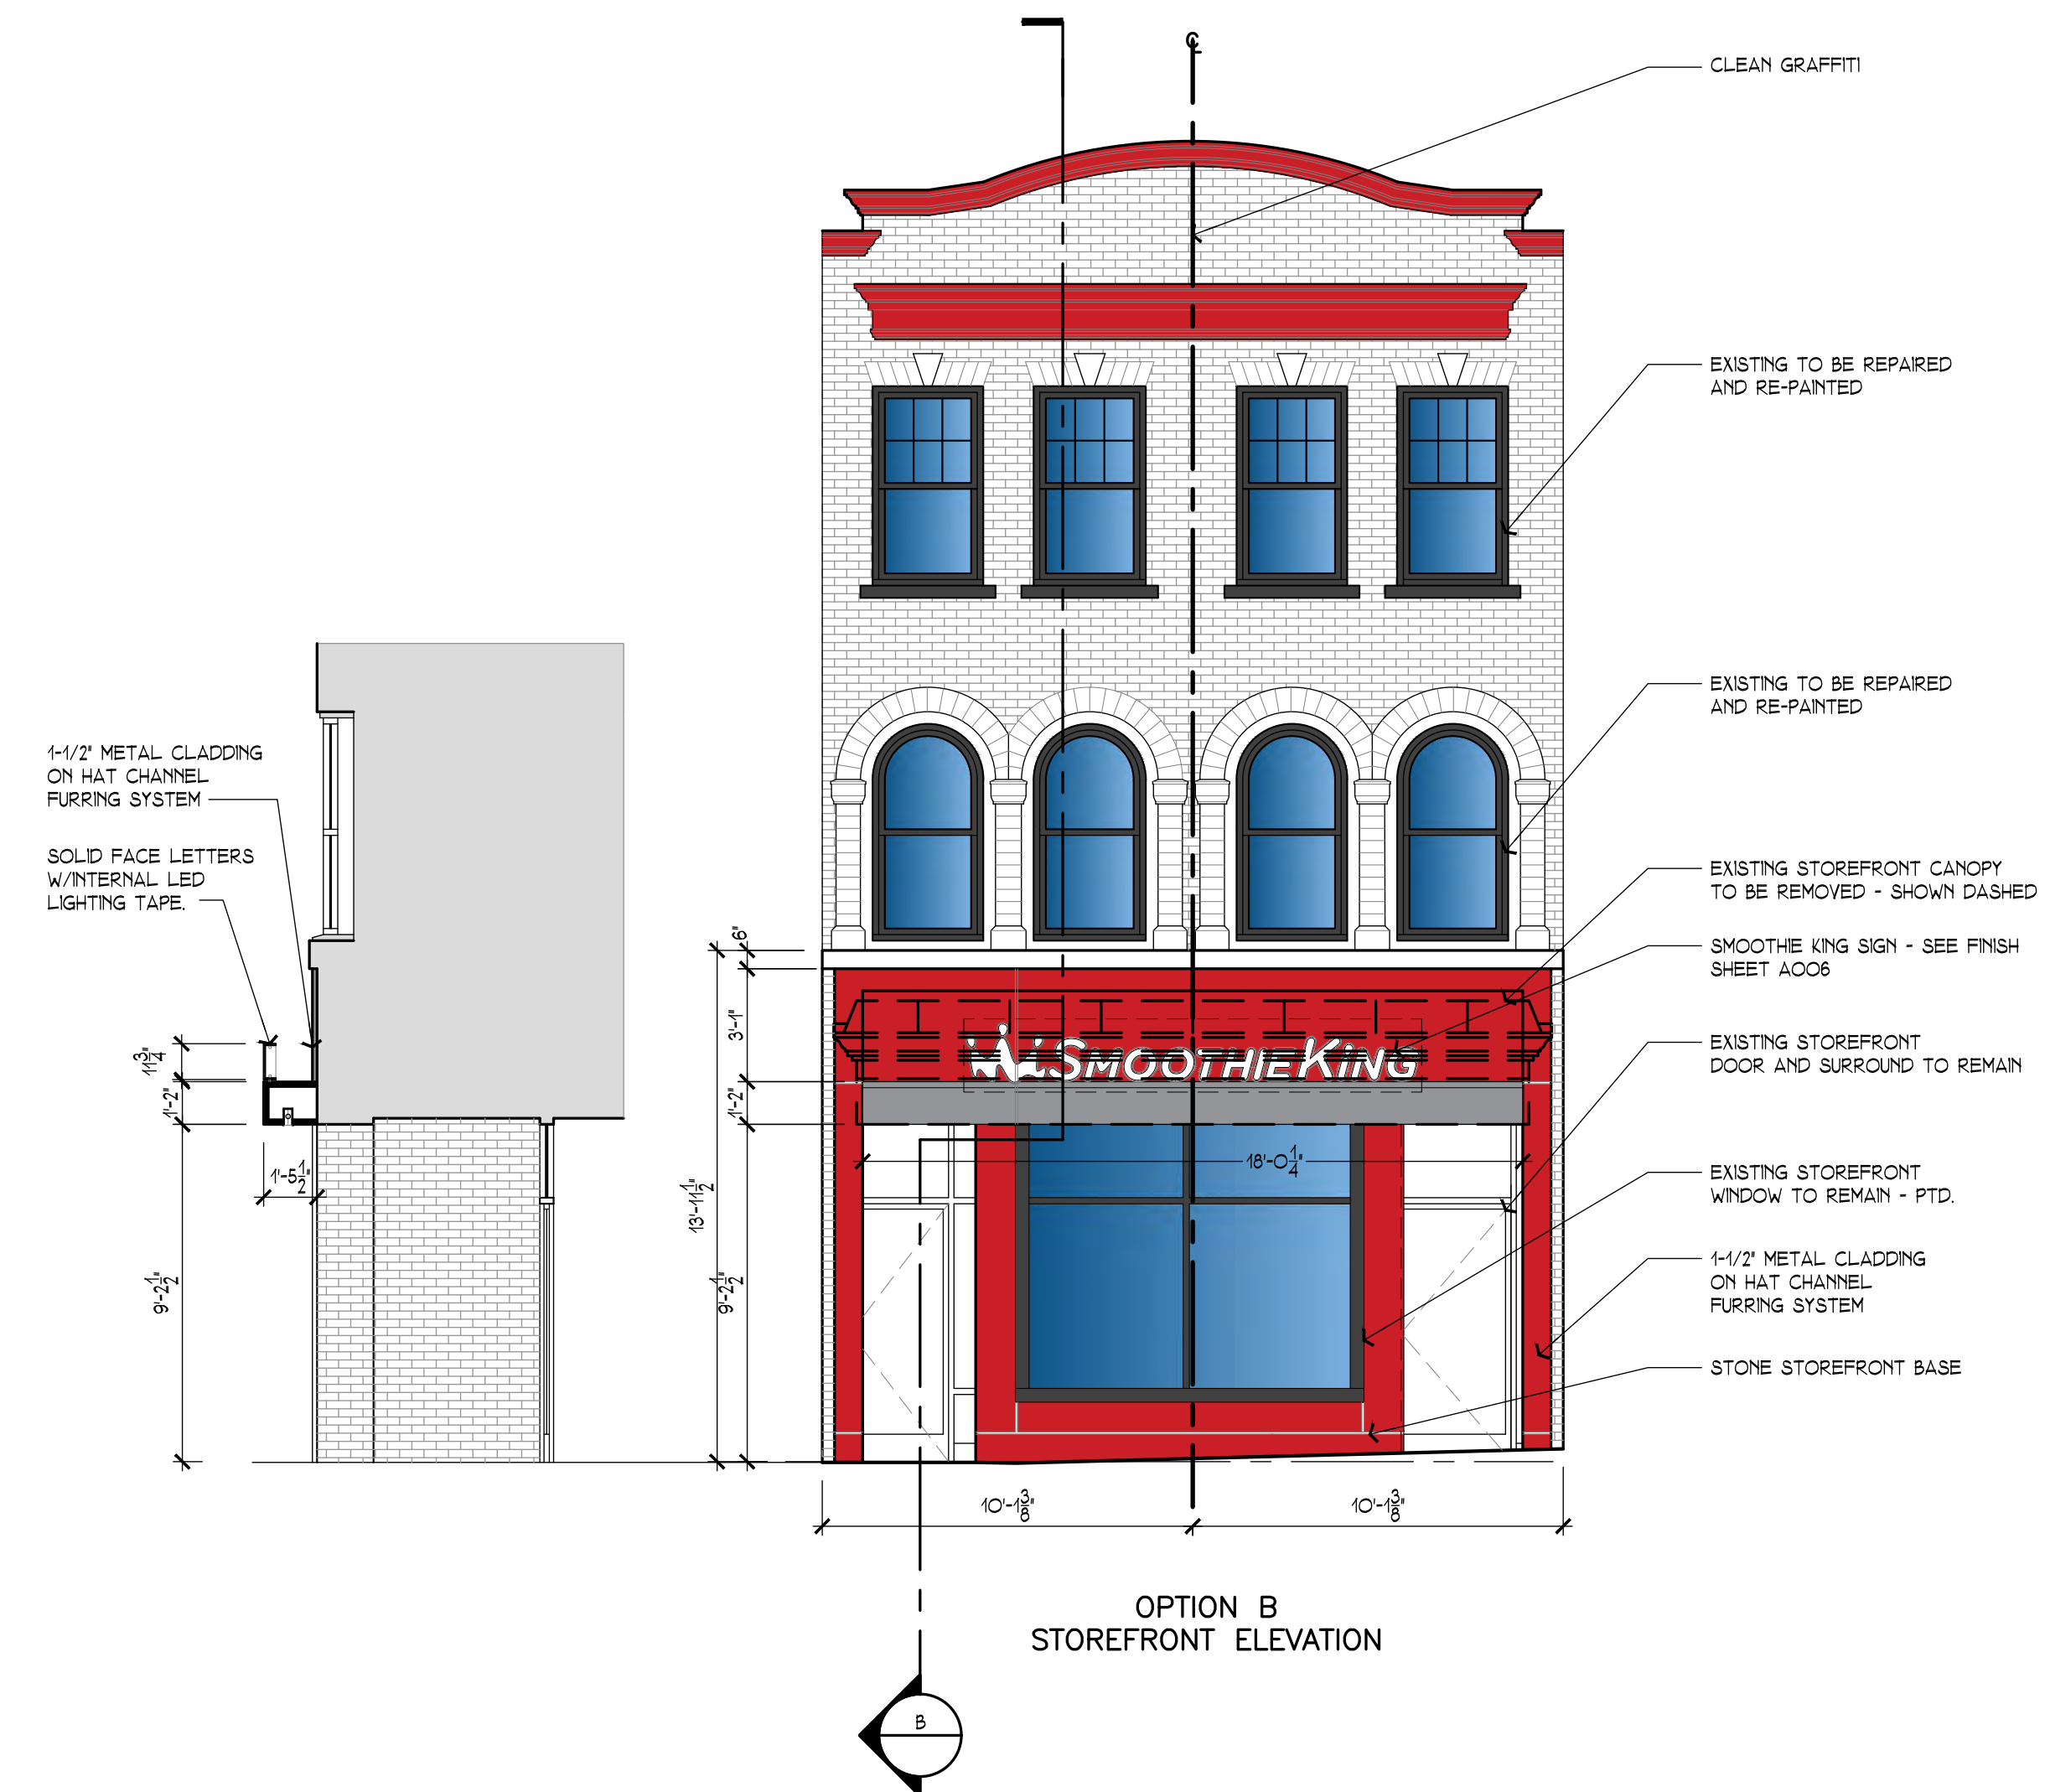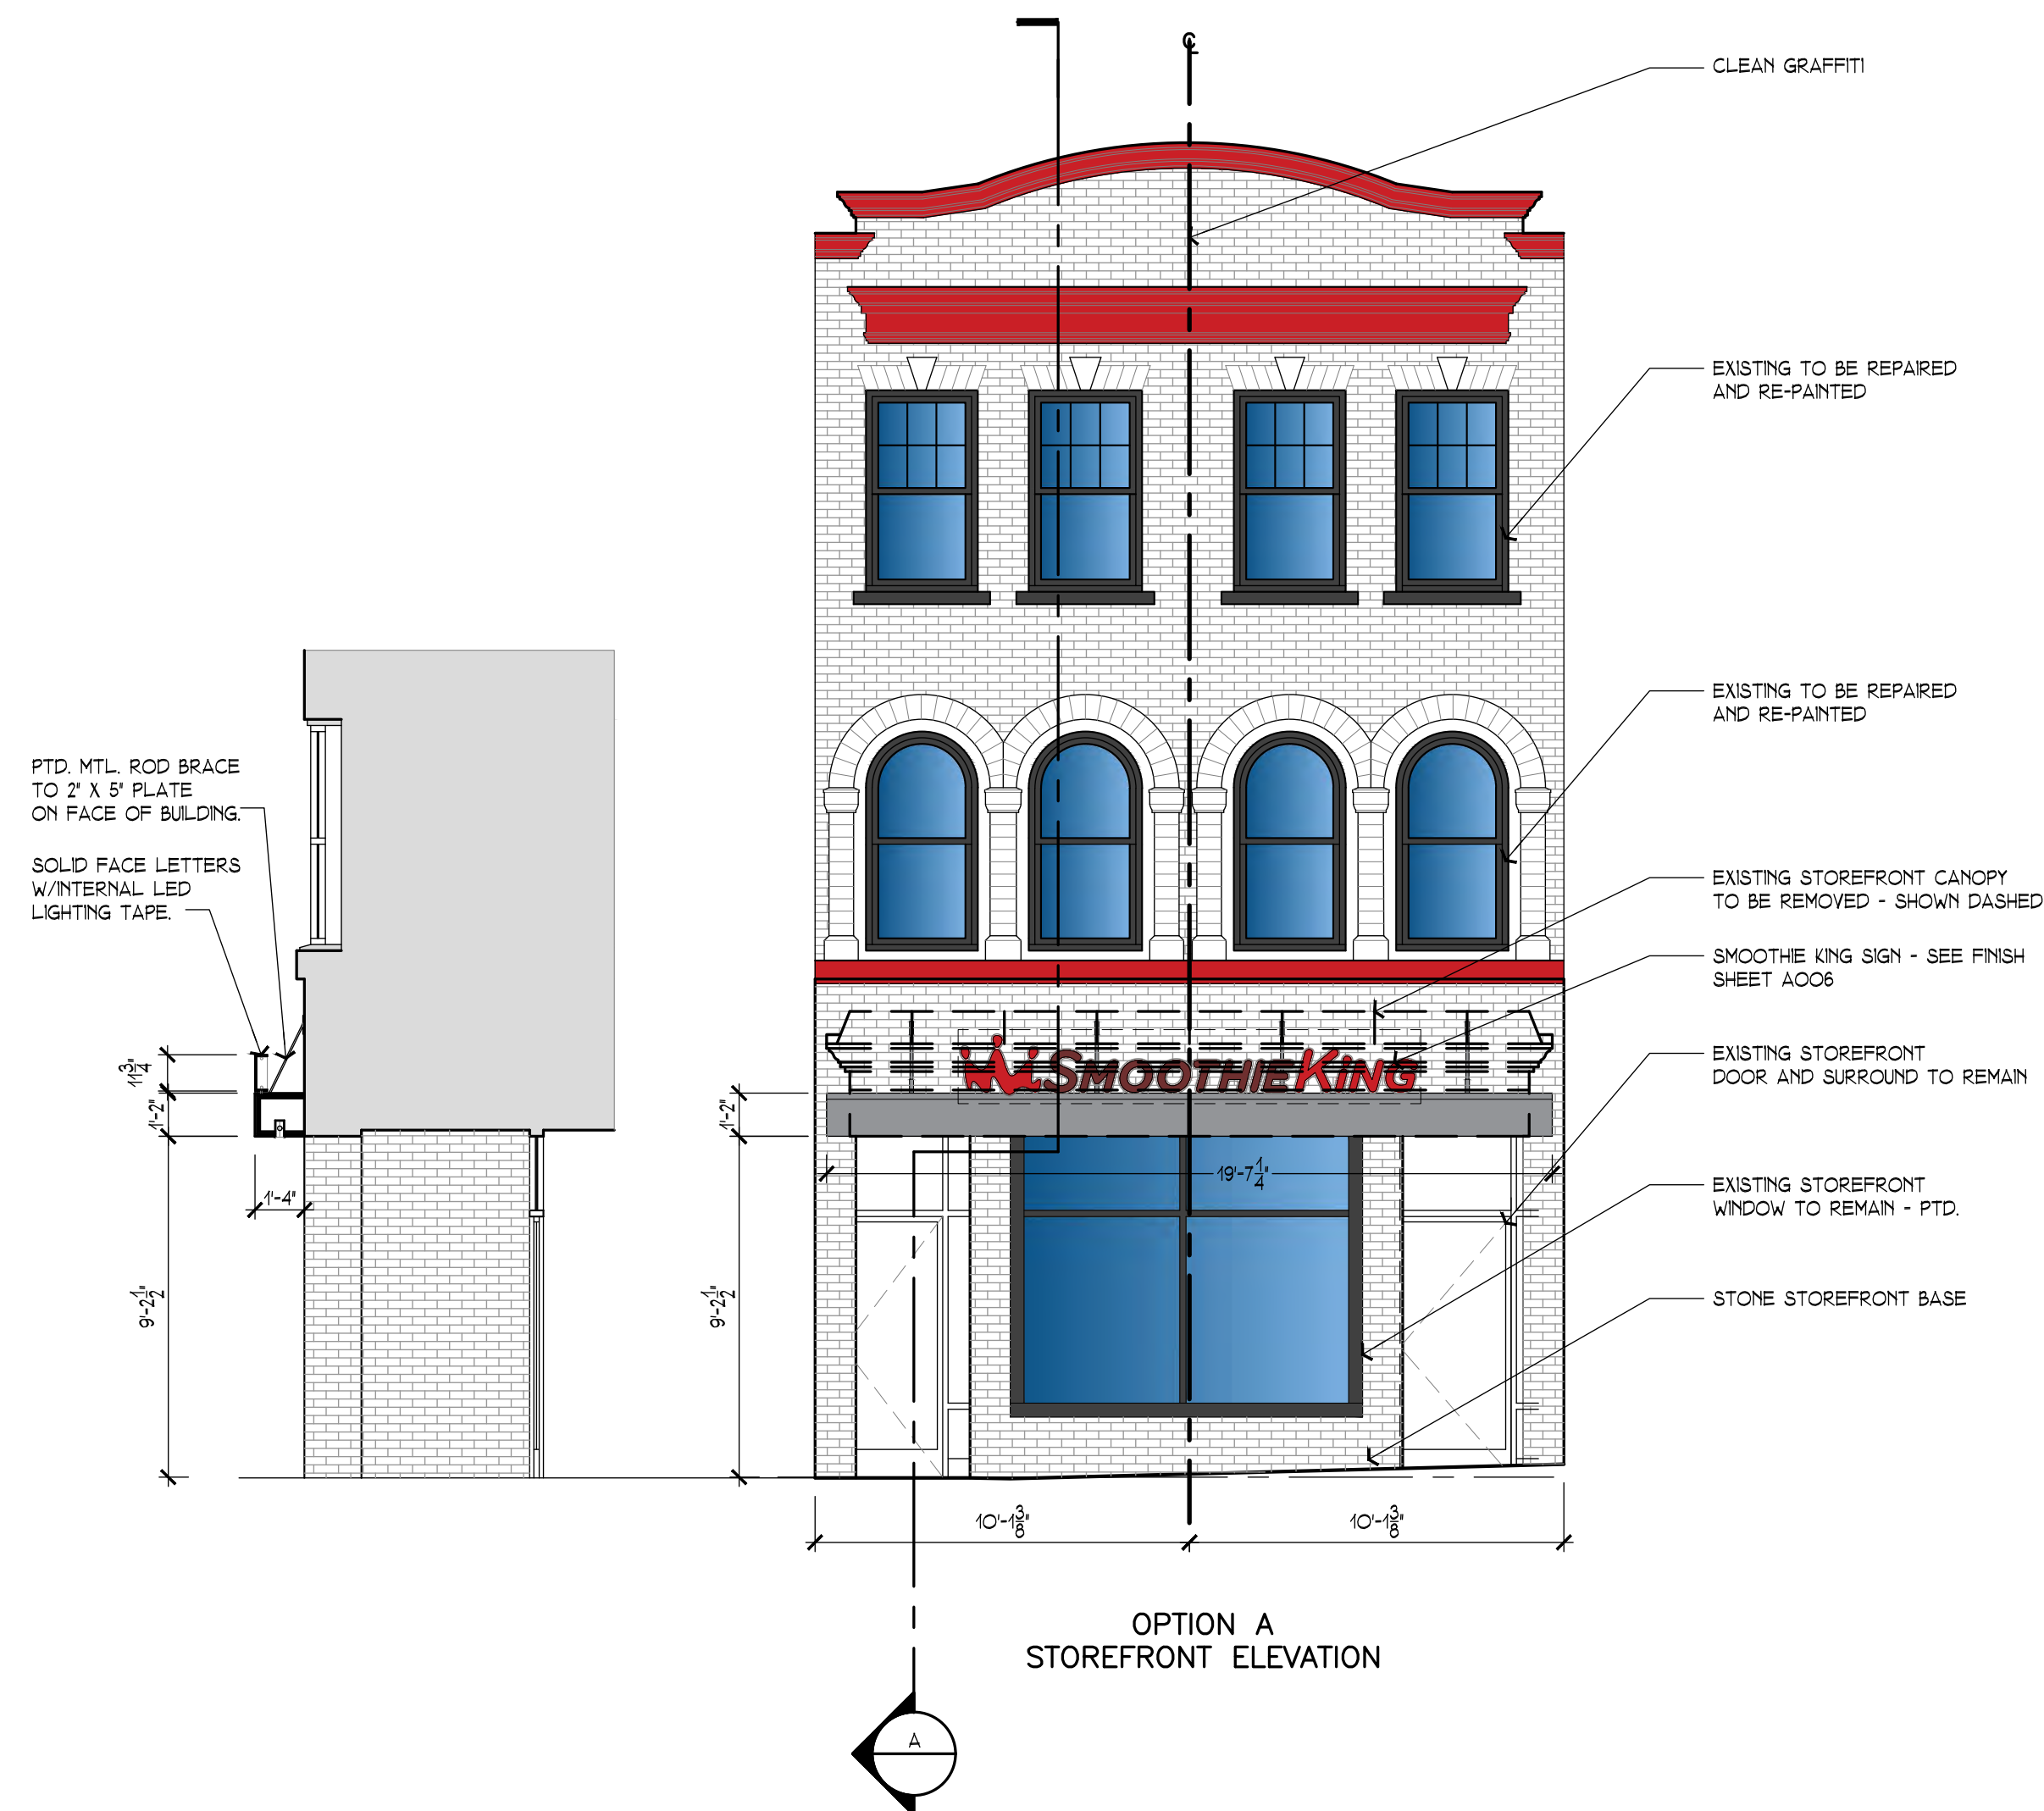

## Proposed Storefront Elevations & Plans

Scale:  $\frac{1}{4}" = 1'-0"$

3122 M Street NW Washington, D. C. 20007 - Apartment Renovation/Addition  
21 January 2022

A004




DATE: 01/21/2022

EXTERIOR MATERIALS SCHEDULE	
EX-4	PRE-FINISHED BRAKE METAL, ZINC COAT FINISH
EXTERIOR PAINT FINISH SCHEDULE	
P-1	PAINT: SW 7008 ALABASTER, SEMI GLOSS
P-2a	PAINT: SW 6321 RED BAY, SEMI GLOSS


SIGNAGE



LIGHTING:  
Initial letters "S" and "K" to be 15" tall. Body of text to be 11-3/4" tall. Letters to have solid faces, with "halo" light from the rear of the letter.

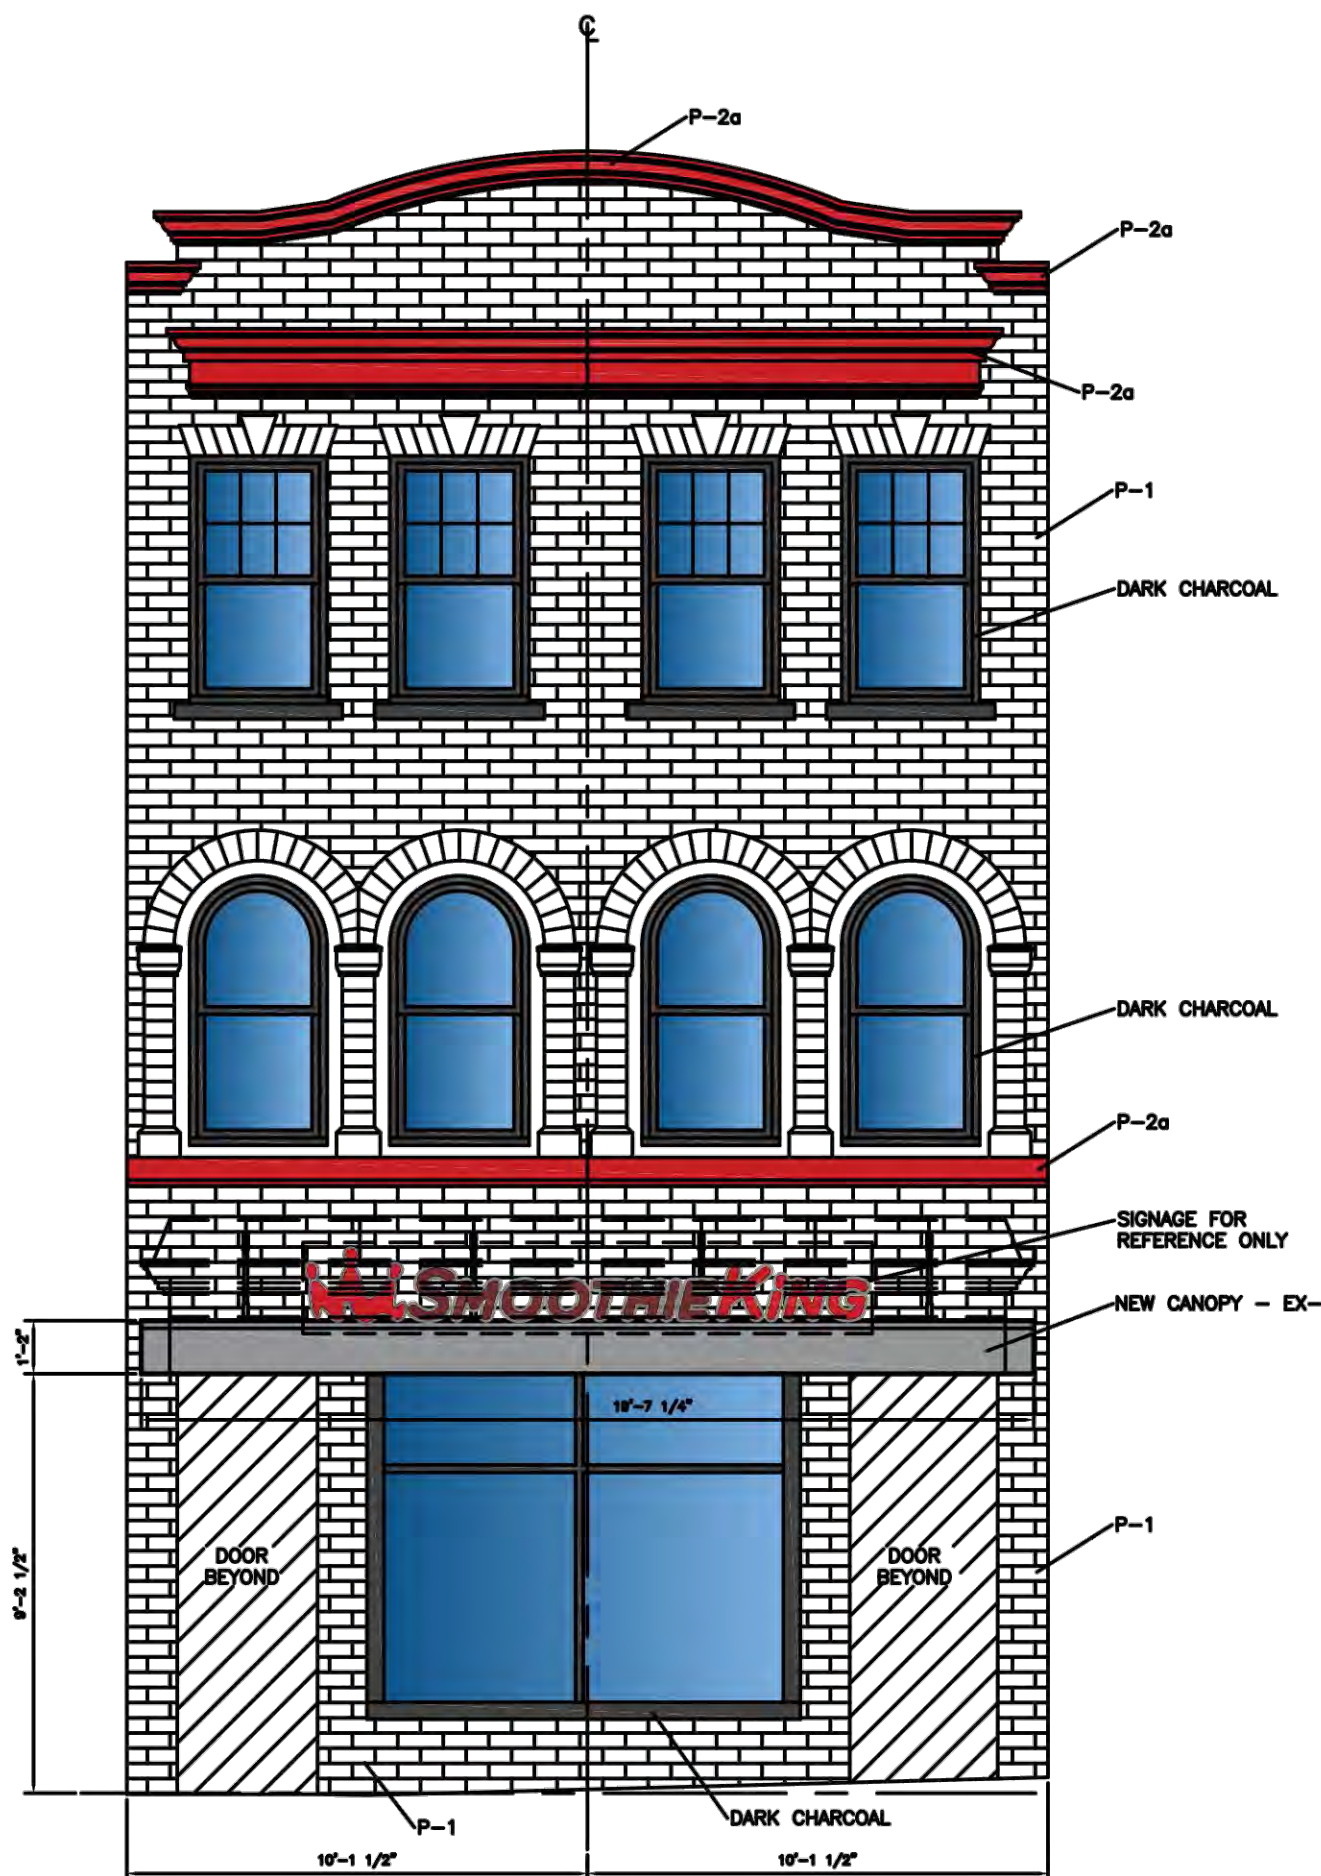

OPTION A

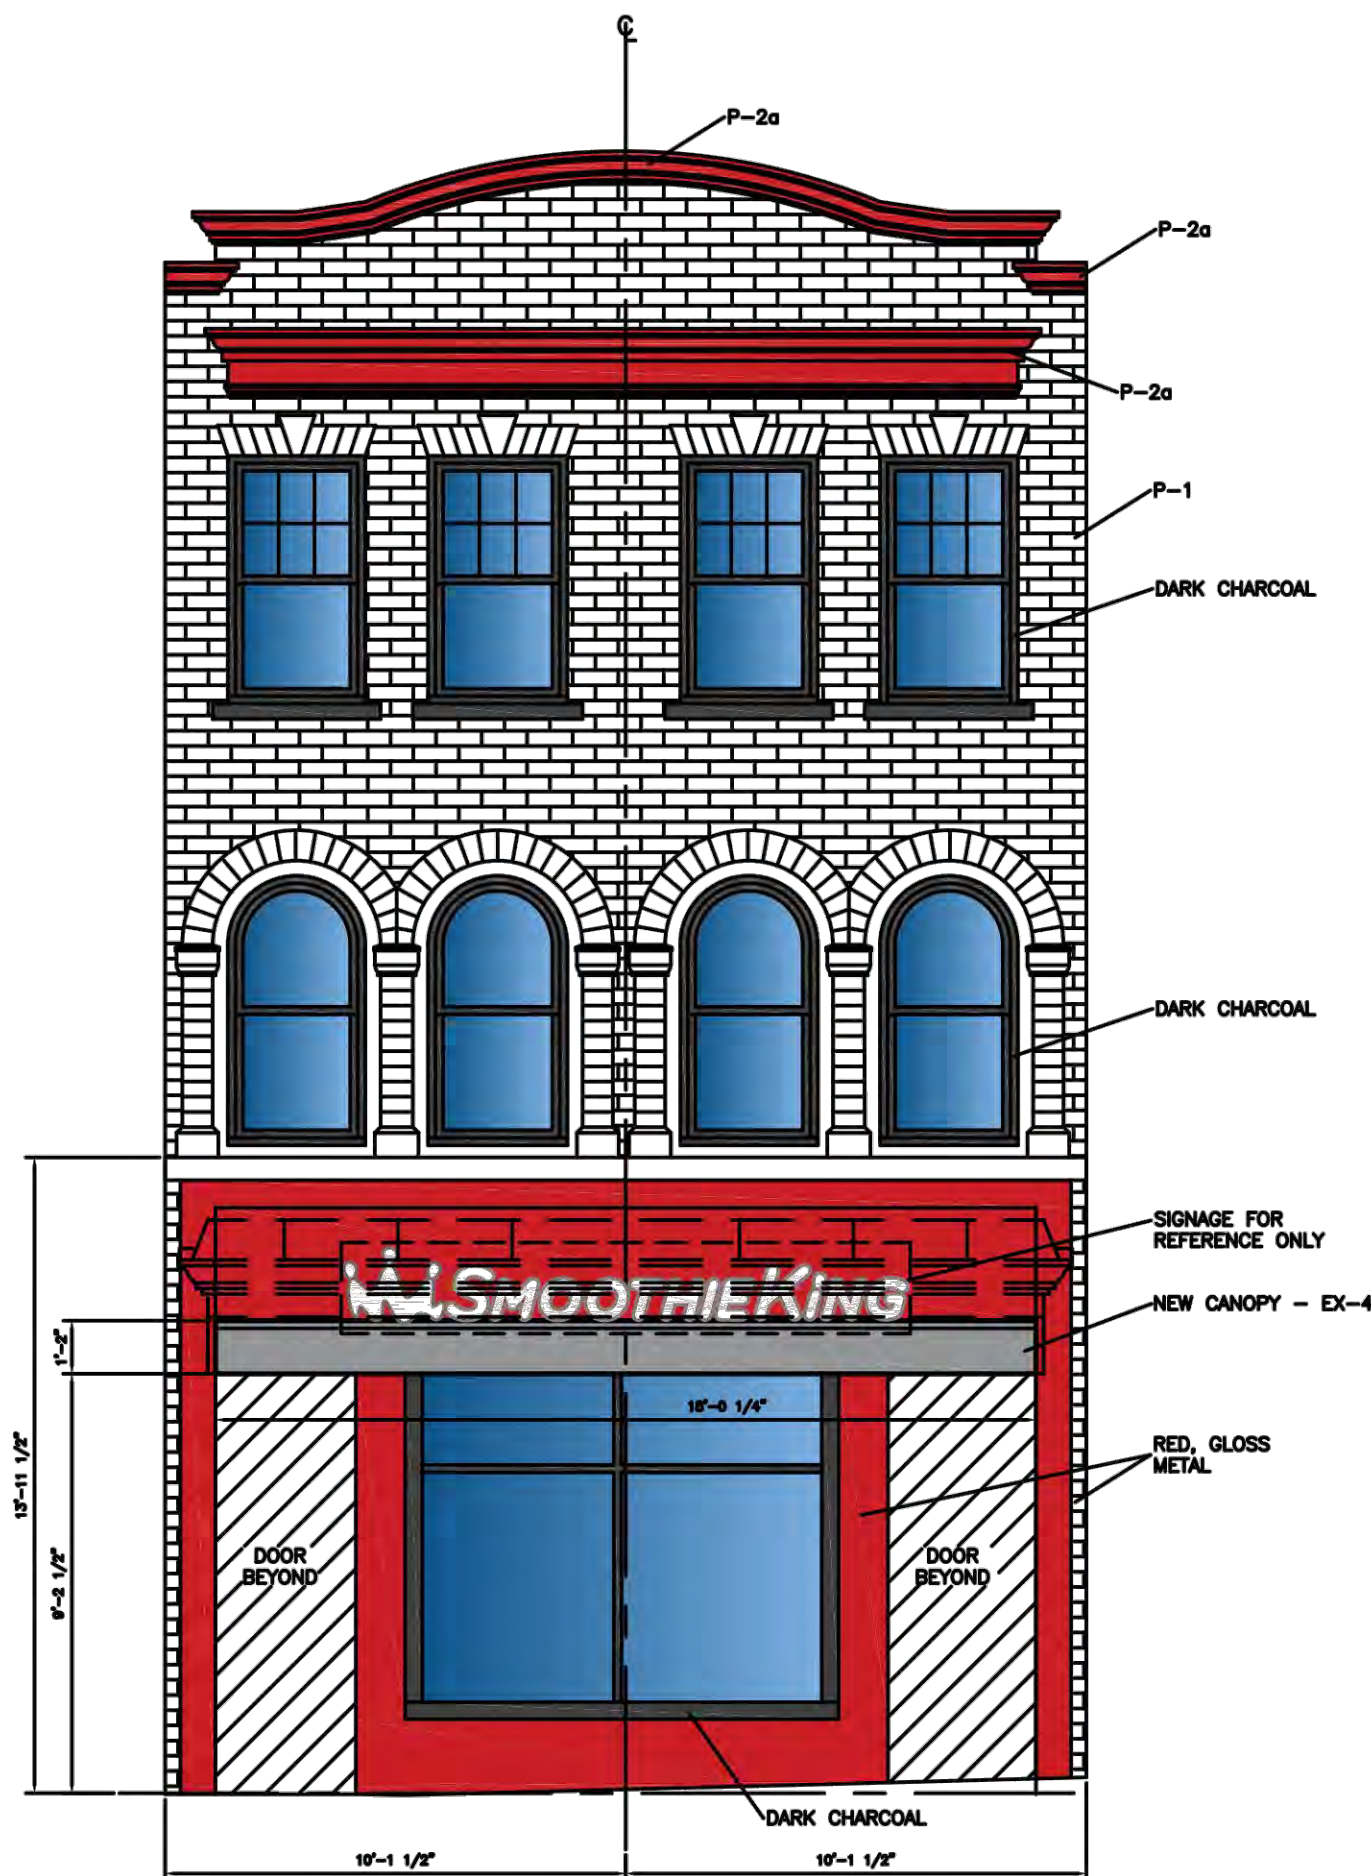

OPTION B

SMOOTHIE KING FRANCHISES, INC.  
9797 ROMBAUER RD. SUITE 150  
DALLAS, TX 75019  
PH (214) 935-8900 FAX (214) 432-5732

THIS DRAWING IS GIVEN IN CONFIDENCE AND SHALL BE USED ONLY UPON THE EXPRESS WRITTEN CONSENT OF SMOOTHIE KING FRANCHISES INC. NO OTHER USE, DISSEMINATION OR DUPLICATION MAY BE MADE WITHOUT THE WRITTEN CONSENT OF SMOOTHIE KING FRANCHISES INC. ALL COMMON RIGHTS OF COPYRIGHT AND OTHERWISE ARE HEREBY SPECIFICALLY RESERVED.

SMOOTHIE KING #2043  
TEST ELEVATIONS - RV#3  
SKC  
GEORGETOWN - WASHINGTON DC  
SCALE: 3/16" = 1'-0"




## Proposed Storefront Finishes

Not to Scale

3122 M Street NW Washington, D. C. 20007 - Apartment Renovation/Addition  
21 January 2022



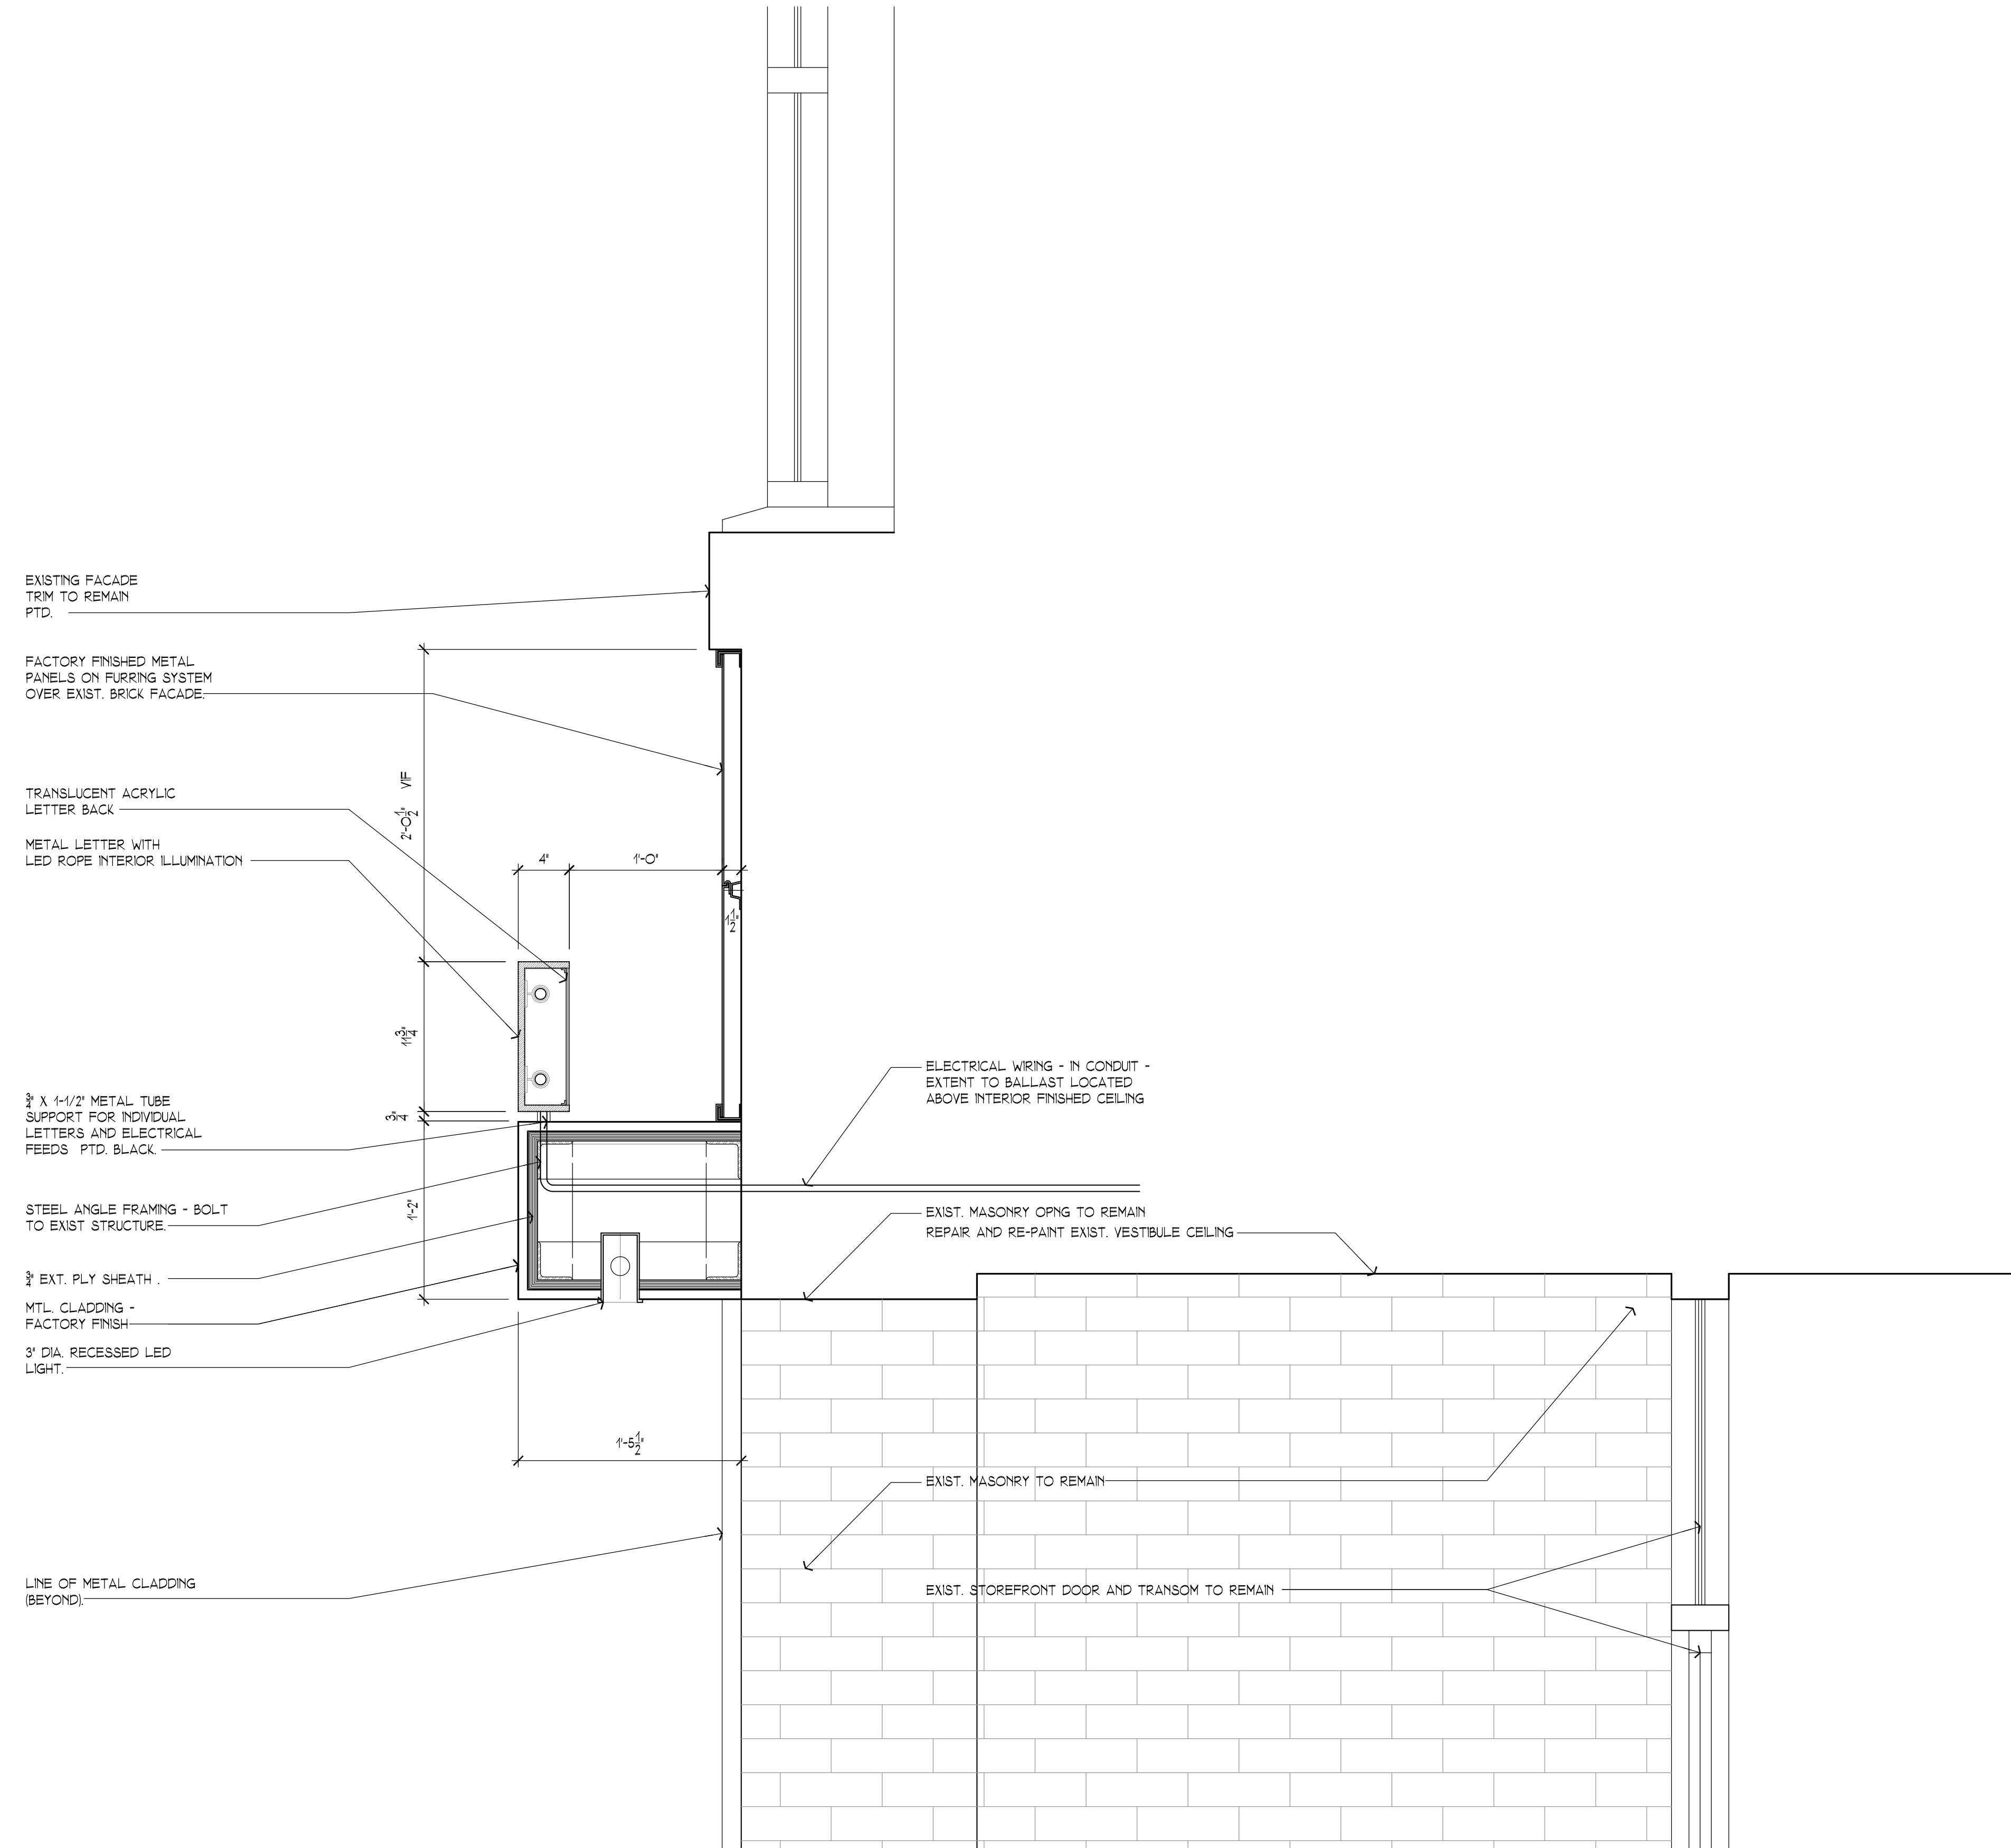

## Proposed Storefront Sign Section

Scale: 1-1/2" = 1'-0"

A007

3122 M Street NW Washington, D. C. 20007 - Apartment Renovation/Addition  
21 January 2022





## W-SERIES (WIDE) FLEXIBLE LED STRIP LIGHT

Standard Bright (9 LEDs/foot)

**MODEL: AL-SL-W-S**



### Description

aspectLED's Flexible LED strip lights are a perfect solution for a wide variety of architectural and accent lighting applications including; cove lighting, under-cabinet lighting, back-lighting, pathway lighting and decorative lighting. Our Standard Bright W-Series (wide) flexible LED strip lights are made with wire leads on both ends of each 16.4' reel and can be cut every 4" (12VDC), allowing you to cut pieces to the exact length that you need.

[Learn more](#)



[www.aspectLED.com](http://www.aspectLED.com) | 888.503.1317 | [sales@aspectled.com](mailto:sales@aspectled.com)

For general information purposes only. Specifications, dimensions and construction not guaranteed and are subject to change without notice. Copyright © 2020 ASP Holdings, Inc. All rights reserved.



4900 Constellation Drive | Saint Paul, MN 55127




	NON-WATERPROOF	WATER RESISTANT	WATERPROOF
<b>Dimensions</b>	3/8" (10mm) wide 1/16" (2mm) thick 16.4' (5M) long	3/8" (10mm) wide 1/8" (3mm) thick 16.4' (5M) long	1/2" (12.7mm) wide 3/16" (4mm) thick 16.4' (5M) long
<b>Distance Between LEDs</b>	1-1/8" (28.2mm)	1-1/8" (28.2mm)	1-1/8" (28.2mm)
<b>Cut Length</b>	12VDC: 4" (102mm) 24VDC: 6.5" (165mm)	12VDC: 4" (102mm) 24VDC: 6.5" (165mm)	12VDC: 4" (102mm) 24VDC: 6.5" (165mm)
<b>IP Rating</b>	IP20 Indoor Use Dry Location	IP65 Splash Resistant	IP68 Submersible
<b>Adhesive Backing</b>	Yes / 3M Adhesive	Yes / 3M Adhesive	No
<b>Mounting Method</b>	Adhesive Backing	Adhesive Backing	Mounting Straps or Adhesive Caulk
<b>Input Voltage</b>	12VDC or 24VDC	12VDC or 24VDC	12VDC or 24VDC
<b>Beam Angle</b>	120 Degrees	120 Degrees	120 Degrees
<b>Dimmable</b>	Yes	Yes	Yes
<b>Max Power Consumption</b>	2.2 Watts per foot (7.2 Watts per meter)	2.2 Watts per foot (7.2 Watts per meter)	2.2 Watts per foot (7.2 Watts per meter)
<b>Max Luminous Flux</b>	Up to 192 Lumens per foot (varies by LED color)	Up to 192 Lumens per foot (varies by LED color)	Up to 192 Lumens per foot (varies by LED color)
<b>LED Color</b>	Warm White, Neutral White, DayWhite, Red, Green, Blue, Yellow	Warm White, Neutral White, DayWhite, Red, Green, Blue, Yellow	Warm White, Neutral White, DayWhite, Red, Green, Blue, Yellow
<b>Color Temperature</b>	Warm White = 3000K Neutral White = 4000K DayWhite = 6000K	Warm White = 3800K Neutral White = 4900K DayWhite = 7000K	Warm White = 3800K Neutral White = 4900K DayWhite = 7000K
<b>LED Type</b>	SMD 5050 LED Chips	SMD 5050 LED Chips	SMD 5050 LED Chips
<b>LED Quantity</b>	9 LEDs per foot (150 per reel)	9 LEDs per foot (150 per reel)	9 LEDs per foot (150 per reel)
<b>Max Run</b>	16.4 feet @ 12VDC 32 feet @ 24VDC	16.4 feet @ 12VDC 32 feet @ 24VDC	16.4 feet @ 12VDC 32 feet @ 24VDC
<b>Weight</b>	0.4 lbs per reel	0.6 lbs per reel	1.0 lbs per reel
<b>Estimated Lifespan</b>	50,000 hours	50,000 hours	50,000 hours
<b>Warranty</b>	1 Year	1 Year	1 Year
<b>Suitable Uses</b>	Dry Location Only	Dry or Damp Locations	Dry, Damp or Wet Locations
<b>Standards/Certifications</b>	UL Listed, RoHS	UL Listed, RoHS	UL Listed, RoHS




## Strip Light Dimensions

### 12VDC - NON-WATERPROOF

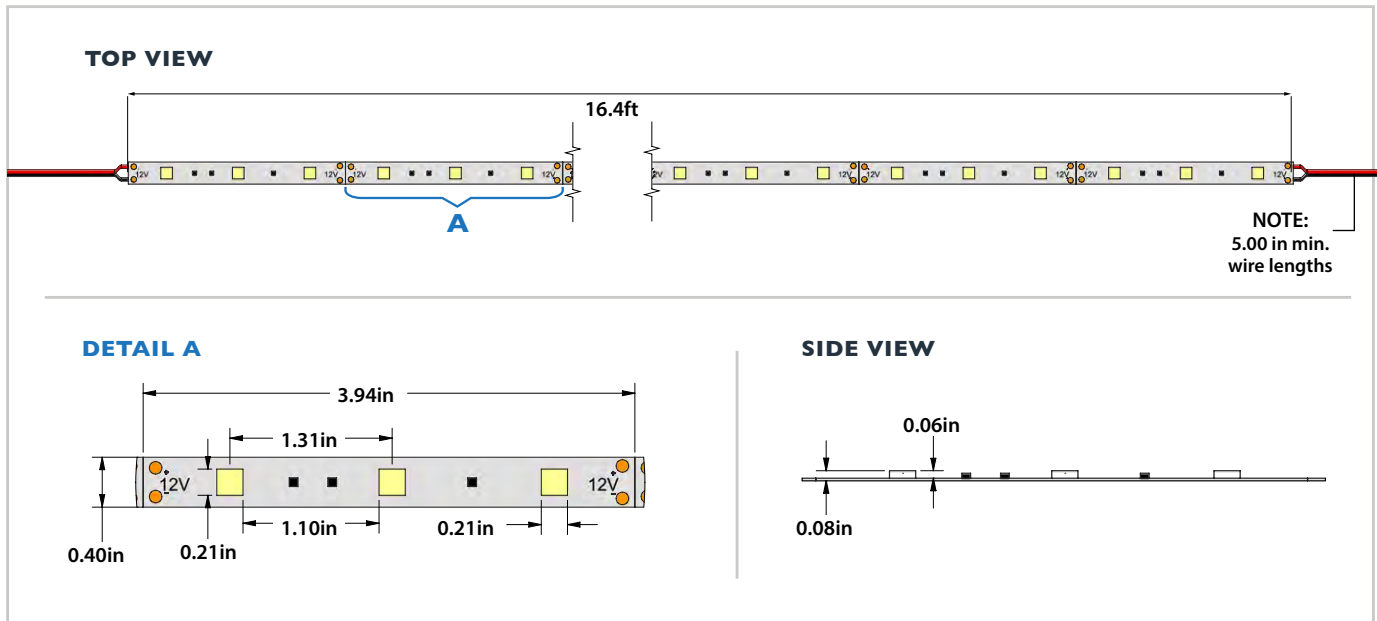


### 24VDC - NON-WATERPROOF

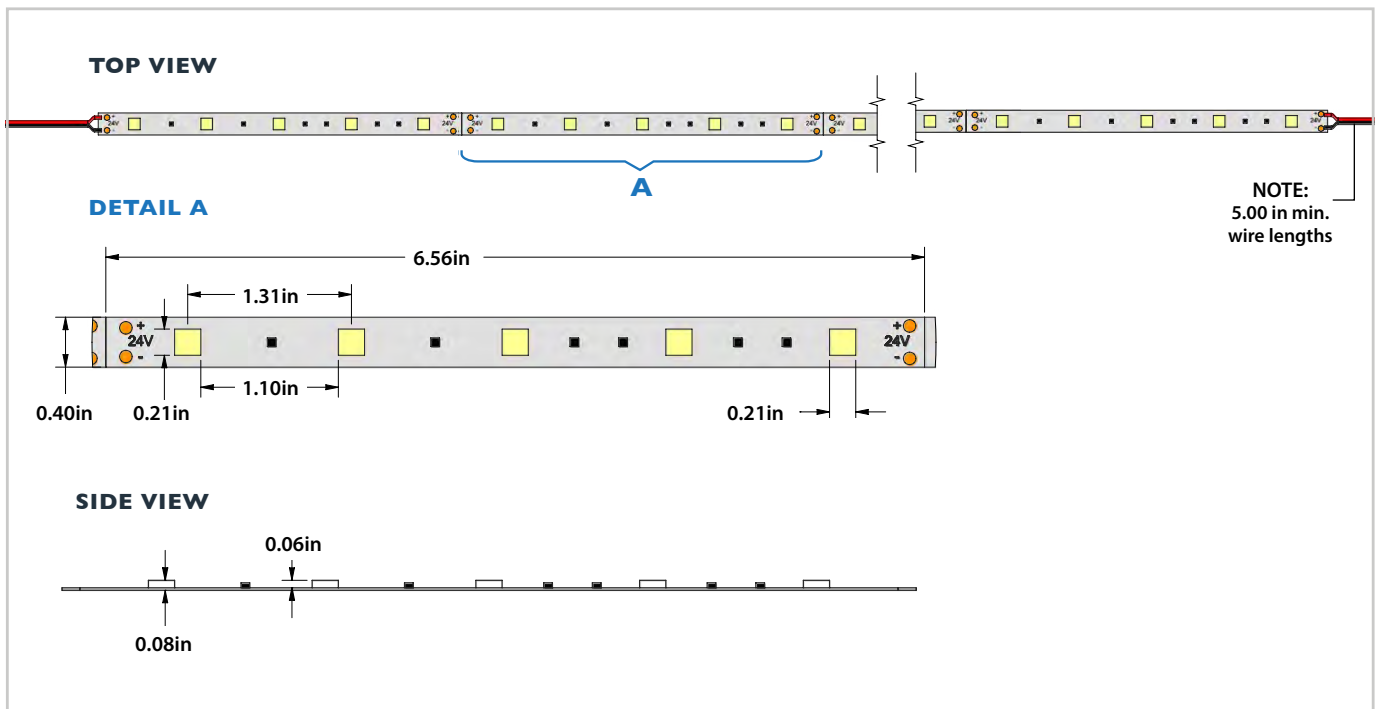




## Strip Light Dimensions

### 12VDC - WATER RESISTANT

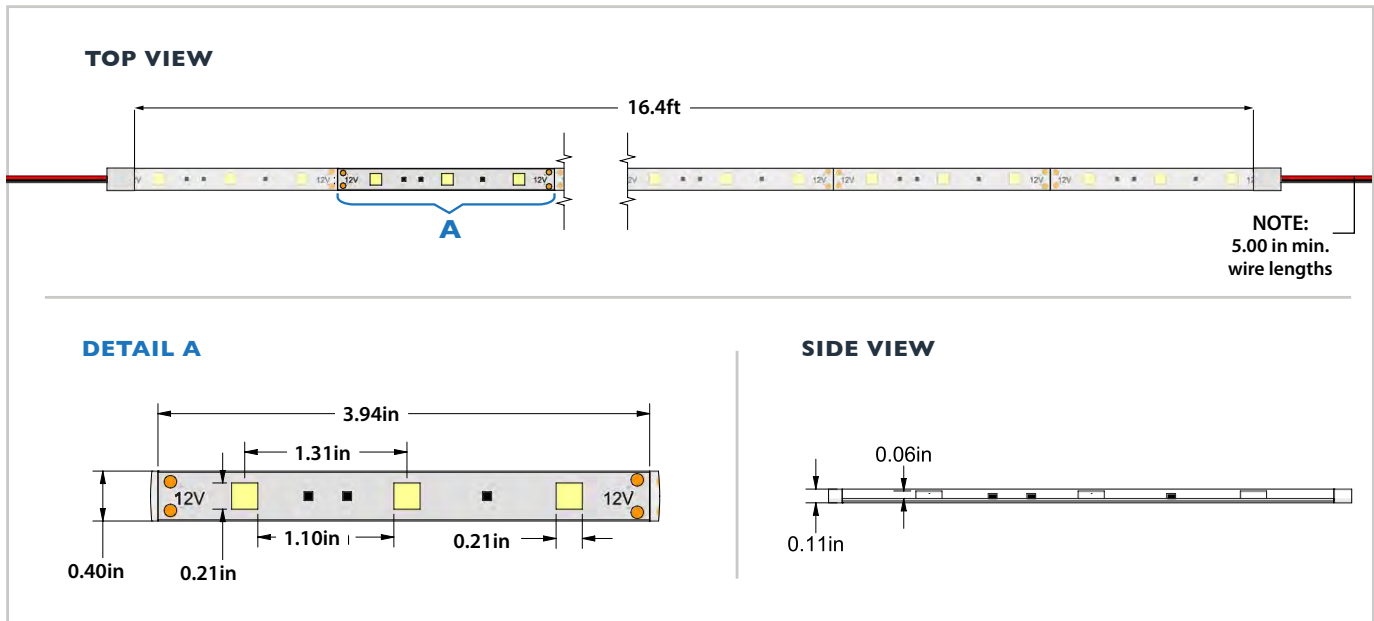


### 24VDC- WATER RESISTANT

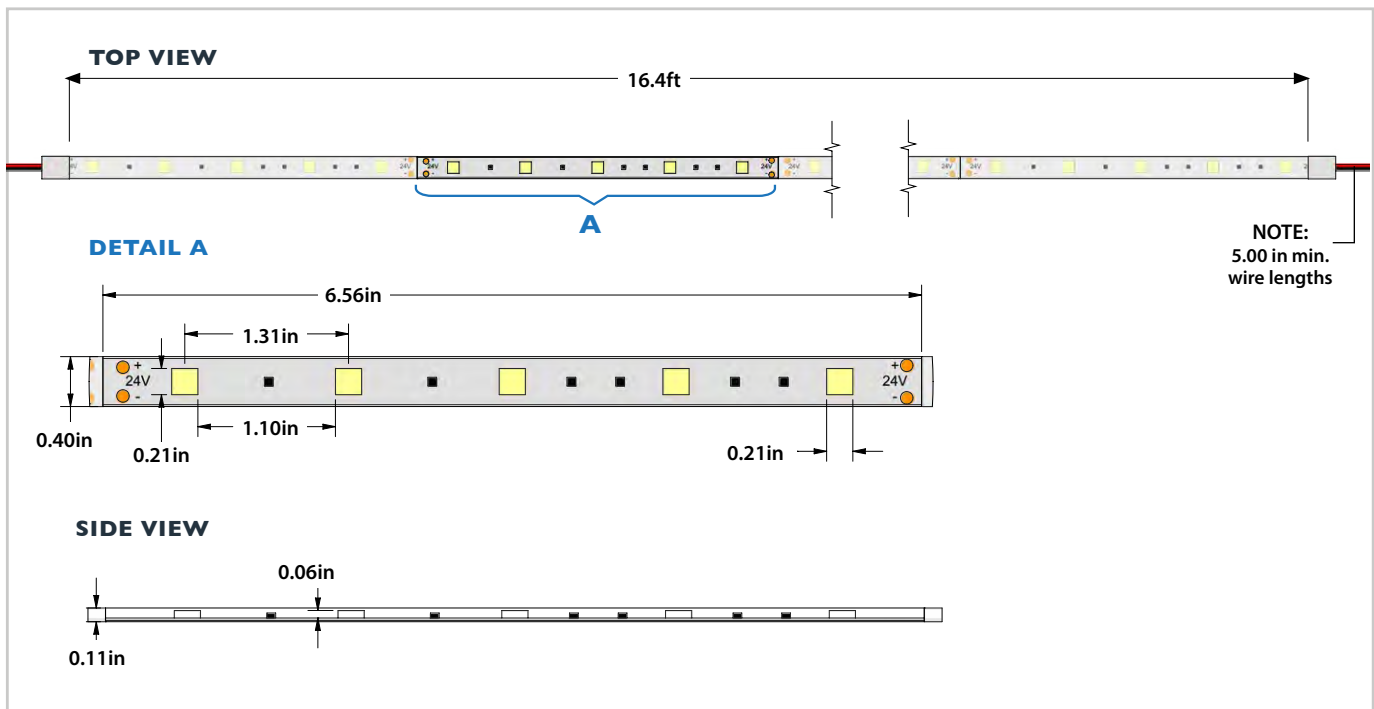




## Strip Light Dimensions

### 12VDC - WATERPROOF

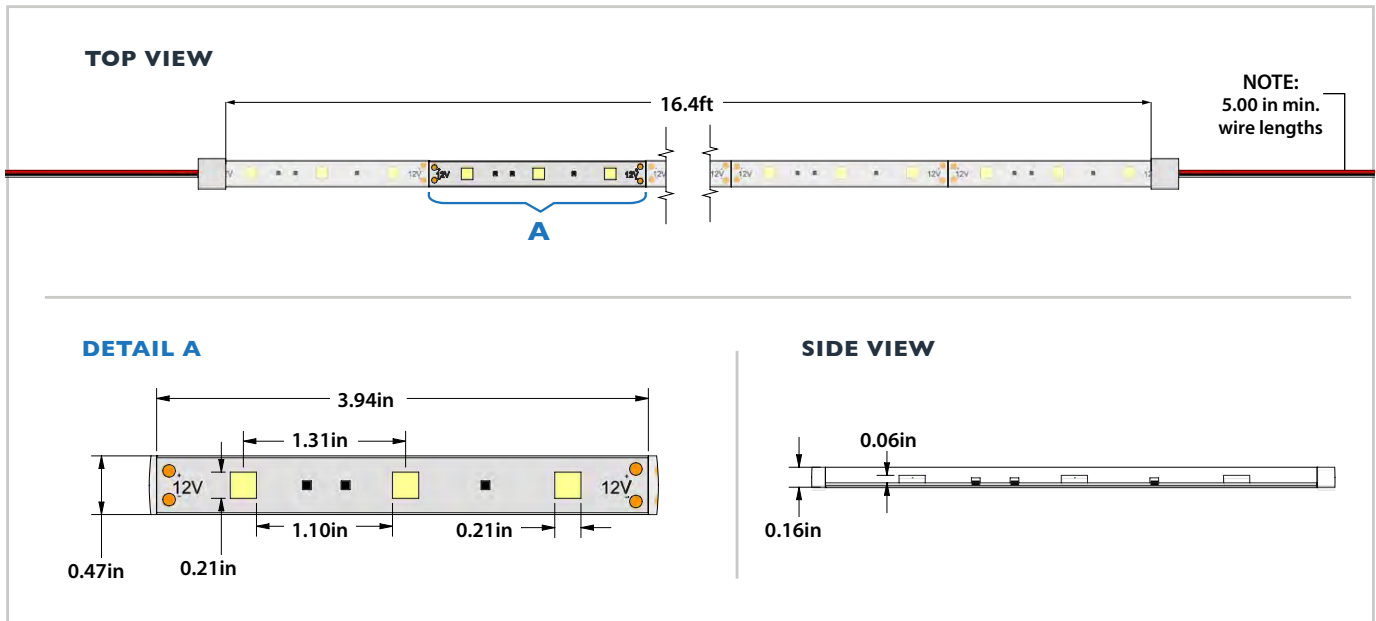

### 24VDC - WATERPROOF

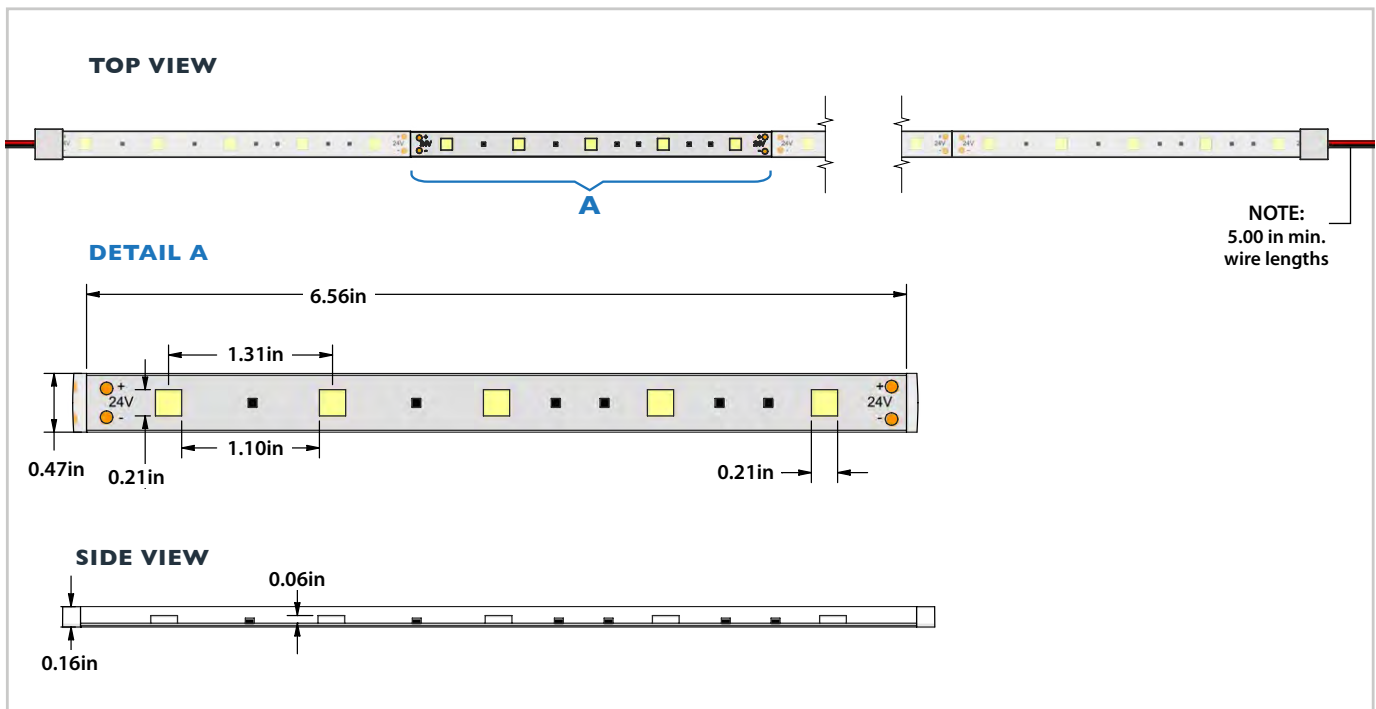



## Accessories

### 30 Watt LED Power Supply

SKU: AL-PS-W-30

### 60 Watt LED Power Supply

SKU: AL-PS-W-60

### 100 Watt LED Power Supply

SKU: AL-PS-W-100

### 200 Watt LED Power Supply

SKU: AL-PS-W-200



### 20W Dimmable Power Supply-24VDC

SKU: AL-PS-W-D-20-24V

### 45W Dimmable LED Power Supply

 
SKU: AL-PS-W-D-45-24V

### 80W Dimmable LED Power Supply

SKU: AL-PS-W-D-80-24V

### MLV Dimmable Power Supply - 200 Watt

SKU: AL-PS-W-200-MLV-12V



## SKU Builder

MODEL #:

AL-SL

WATERPROOFING:

**WN** - Non-Waterproof  
**WR** - Water Resistant  
**WW** - Waterproof

BRIGHTNESS:

**S** - Standard Bright

LED LIGHT COLOR:

**WW** - Warm White  
**NW** - Neutral White  
**DW** - DayWhite  
**R** - Red  
**G** - Green  
**B** - Blue  
**Y** - Yellow/Amber

VOLTAGE:

**12** - 12VDC  
**24** - 24VDC



Project Name:

Type:

Quantity:

## FIXTURE SPECIFICATIONS

### INTENDED USE

This energy-efficient LED product may be used for a variety of residential and commercial spaces. Our recessed, trimless downlighting features a 30° beam angle. The architectural-grade, damp location-approved light includes a range of color temperatures, making the three-inch product perfect for a variety of projects.

### PRODUCT FAMILY

**14143-R** | 3-Inch Trimless Round

**14143-S** | 3-Inch Trimless Square

### ADDITIONAL FEATURES

**Construction:** Type IC-rated, no housing required. Die-cast aluminum with white powder-coat finish. Junction box included with products.

**Beam Angle:** 30°

**CRI:** 90

**Dimming:** Dimmable down to 10% with a standard TRIAC driver

**Operating Temperature:** 104° maximum

**Voltage:** 120VAC

**Lumens:** 700 lm - Up to 70 lumens per watt

**Wattage:** 10W

**Life-span:** 50,000 hours

**Listing:** ETL, JA8/Title 24, Energy Star, Rohs, Damp-location suitable

**Warranty:** 5 years carefree for parts and components (labor not included).



Trimless Round



Trimless Square




Matte Silver

Matte Gold




Matte Silver

Matte Gold

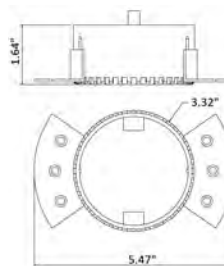

Trimless Round

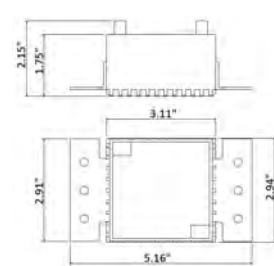


Trimless Square



## ORDERING INFORMATION Example: (14143-R-WH-30K)

Model	Shape	Finish	Color Temp
14143	R Round	WH White	27K 2700K
	S Square	BK Black	30K 3000K
		CL Clear	35K 3500K
		MG Matte Gold	40K 4000K
		MSL Matte Silver	50K 5000K

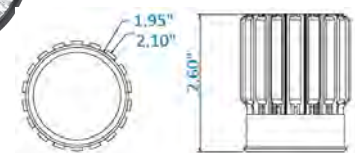

LED Engine


Junction Box  
included with fixtures



## COLOR TEMPERATURE GUIDE

